



-  1000*1000*15MMH 法兰盘 9个
-  100*50H 钢管放通≈86m
-  165*16*6000H 钢立柱 9个
-  400*600H 带轮连接器 13个
-  400*600H 连接器 13个
-  400*600H 铝桁架 37条≈126m

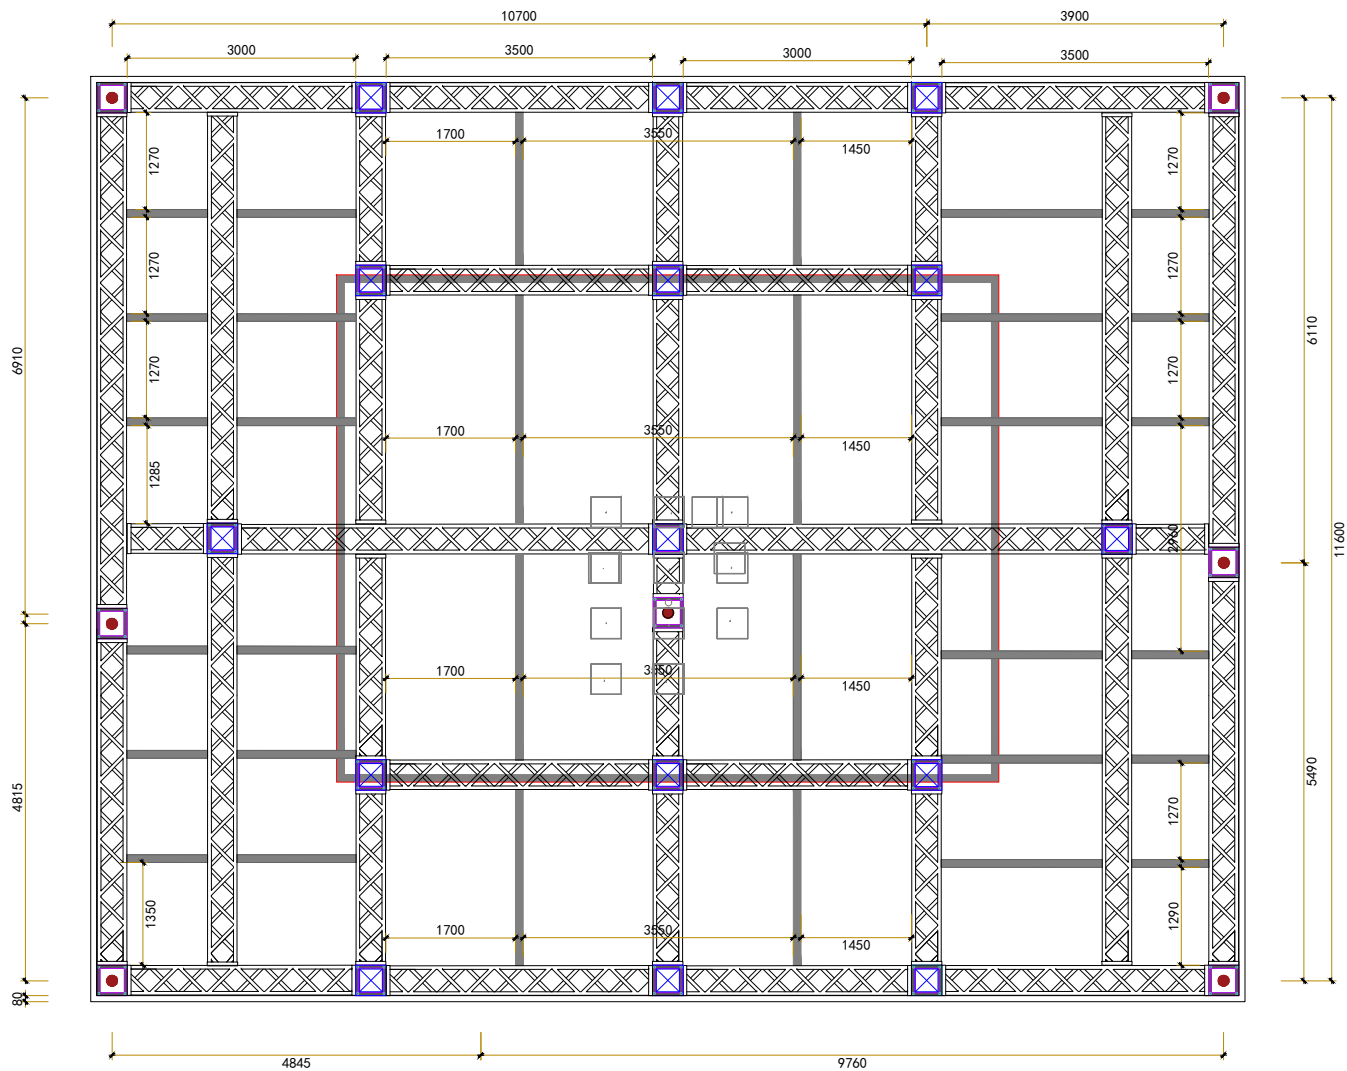



桁架结构落点图
1:60
面积约180平方
H=6000mm

注释: 1.全部设计图例及说明之版权属于本公司 2.所示尺寸均为施工单位现场量测为准 3.图纸如有错误或矛盾之处,以最新出图为准 4.单位: mm(如无特殊注明,单位均为毫米) NOTES 1. All the design plans and that the copyright of the Company without the consent of the Company, shall not be used, copied and reproduced. 2. Shown by the construction unit size, whichever is the scene review. 3. Drawings at the scene and if there are discrepancies, please notify the designer. 4. Unit: mm	展会名称 Exhibition Name	燃气集团	设计 Designer	制图日期 Date	2026.07	展馆 Venne	图号 Drawing No.
	公司名称 Company Name		审核 Approved by	比例 Scale	A2	展位号 Hall No.	

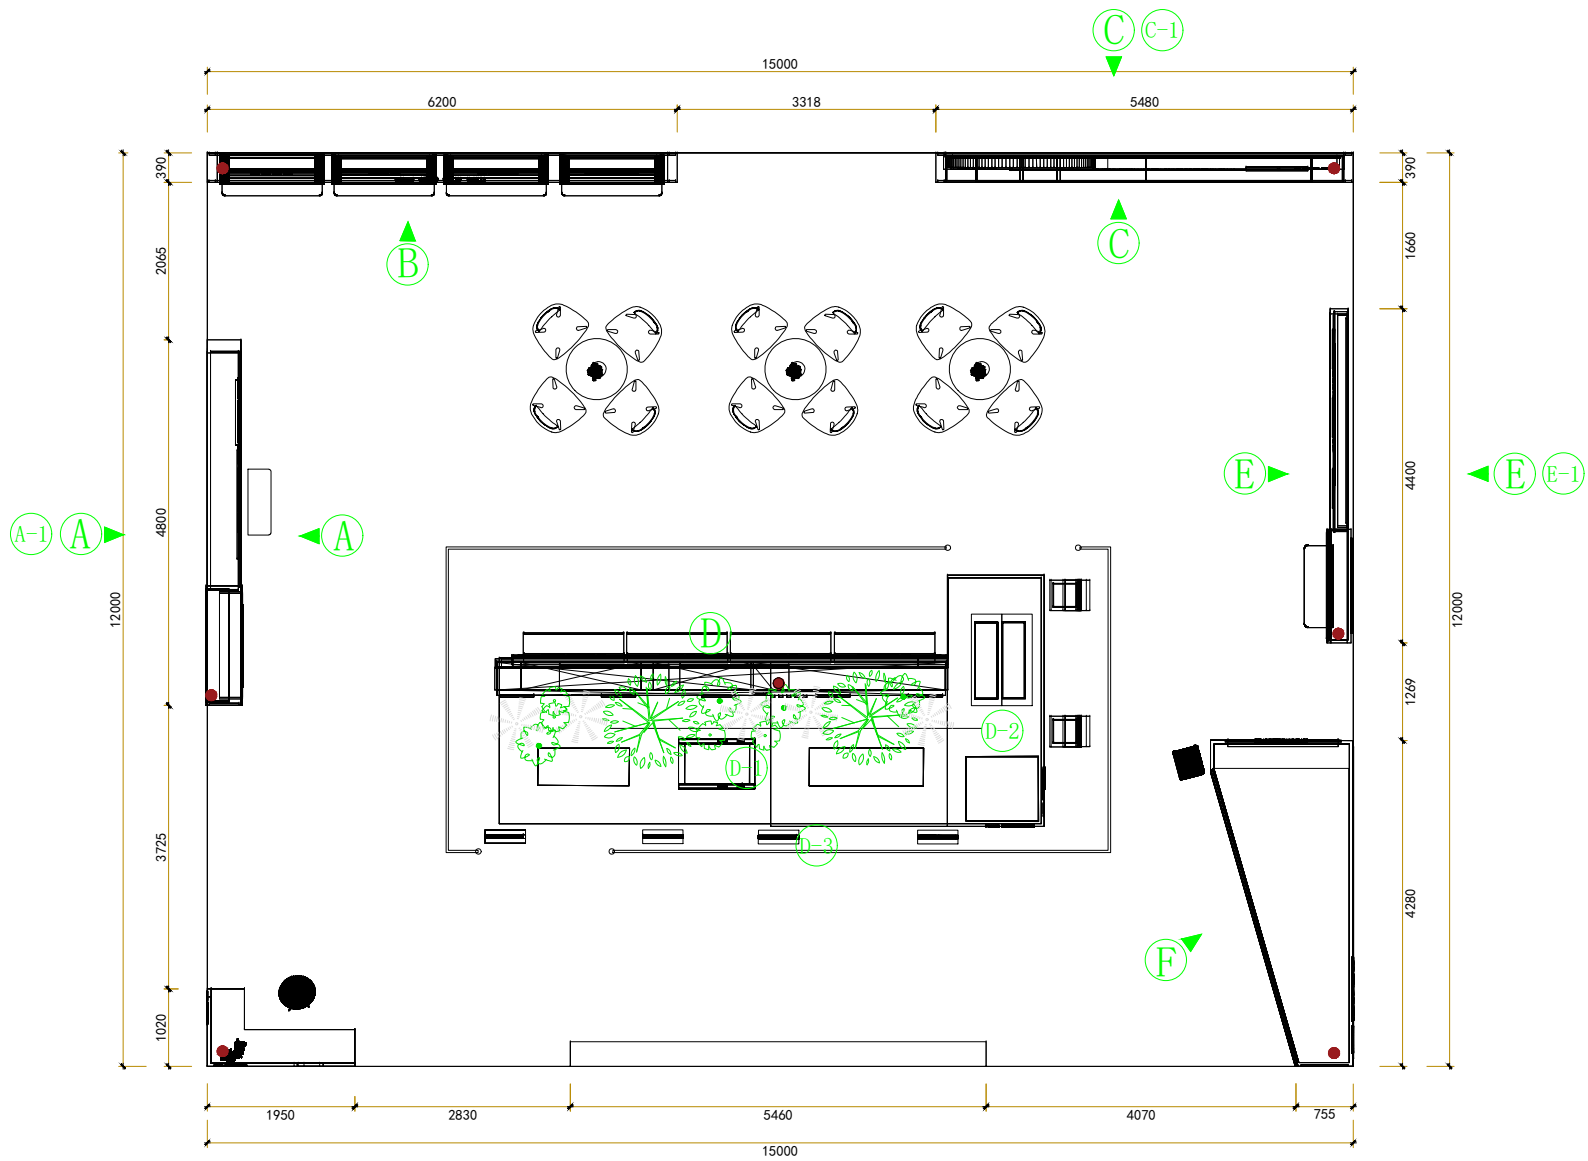

平面布置-索引图
面积约180平方
H=6000mm


注: 1.全部设计图则及说明之版权属于本公司 2.所示尺寸皆由施工单位现场量测为准 3.图则若有与现场不符之处,应以现场设计为准 4.单位: mm(如无特殊注明单位尺寸为毫米) NOTES 1. All the design plans and that the copyright of the Company without the consent of the Company, shall not be used, copied and reproduced. 2. Shown by the construction unit size, whichever is the scene review. 3. Drawings at the scene and if there are discrepancies, please notify the designer. 4. Unit: mm	展会名称 Exhibition Name	燃气集团	设计 Designer	制图日期 Date	2026.07	展馆 Venne	图号 Drawing No.
	公司名称 Company Name		审核 Approved by	比例 Scale	A2	展位号 Hall No.	

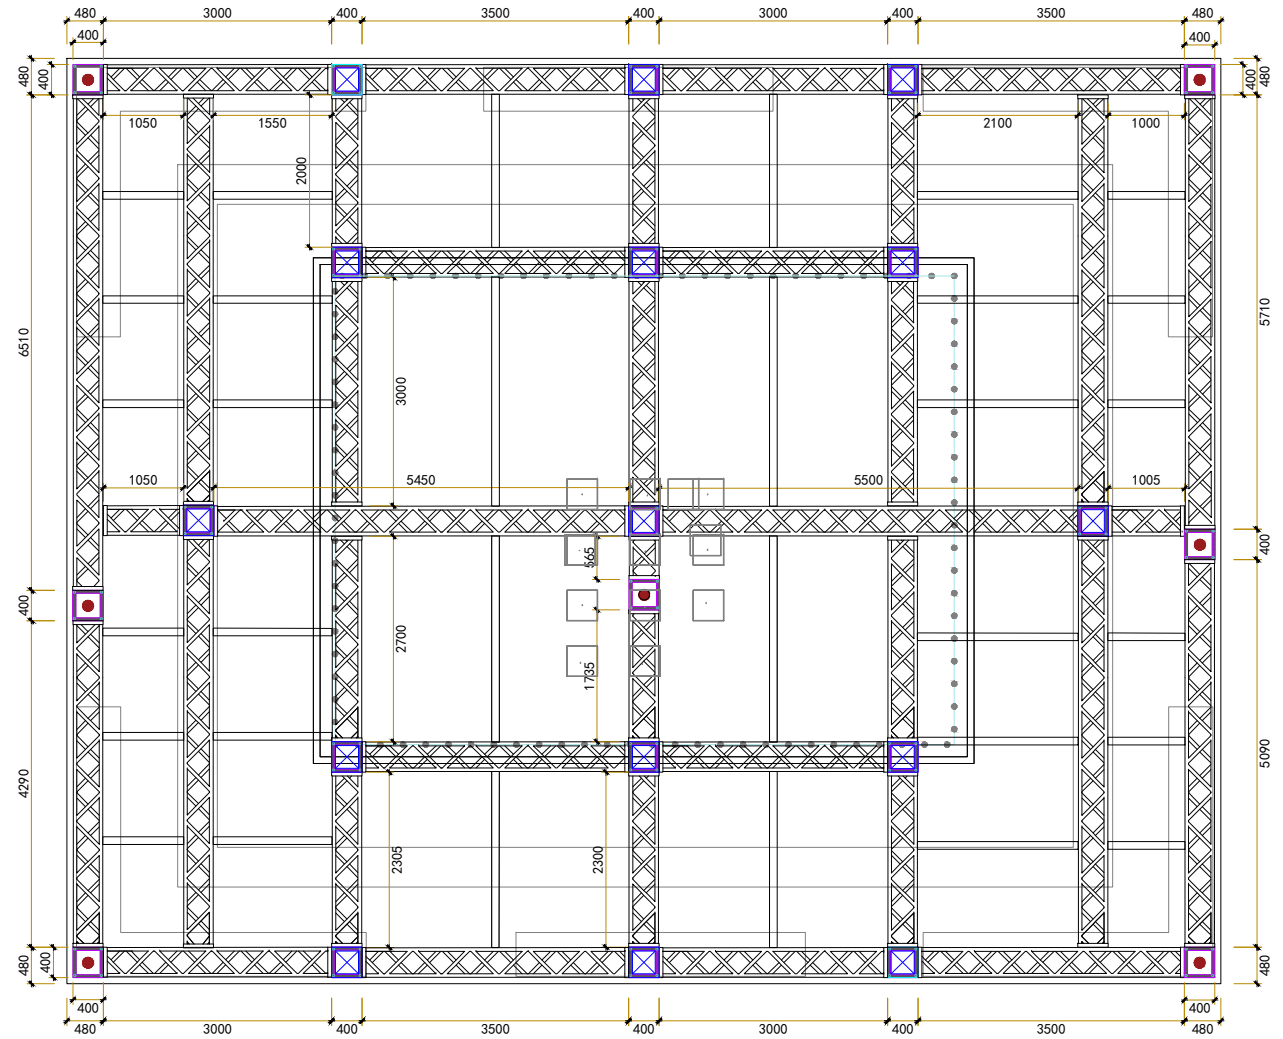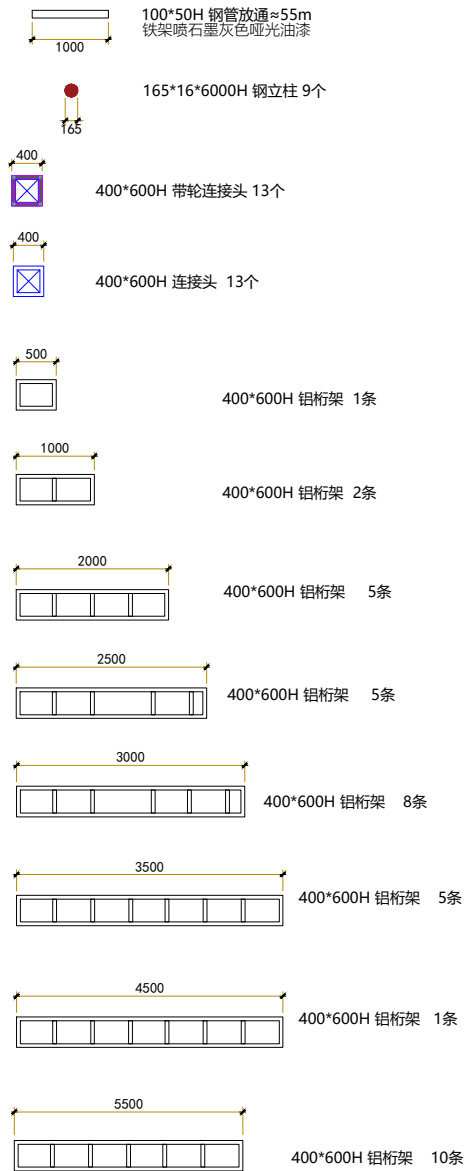


天花布置图
面积约180平方
H=6000mm

注释: 1.全部设计图例及说明之版权属于本公司 2.所示尺寸均为施工现场量测为准 3.图纸如有与现场不符之处,以现场实际情况为准 4.单位: mm(如无特殊注明,单位均为毫米) NOTES 1. All the design plans and that the copyright of the Company without the consent of the Company shall not be used, copied and reproduced. 2. Shown by the construction unit size, whichever is the scene review. 3. Drawings at the scene and if there are discrepancies, please notify the designer. 4. Unit: mm	展会名称 Exhibition Name	燃气集团	设计 Designer	制图日期 Date	2026.07	展馆 Venne	图号 Drawing No.
	公司名称 Company Name		审核 Approved by	比例 Scale	A2	展位号 Hall No.	

 
桁架节点图




俯视图 1:100

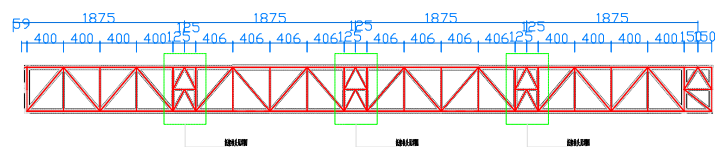


正视图 1:100

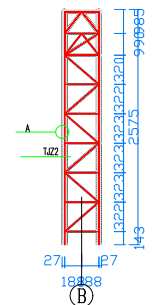


側视图 1:100

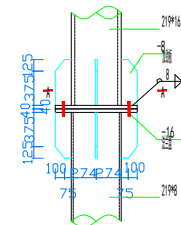


A 1:10
TJZ1主管拼接节点

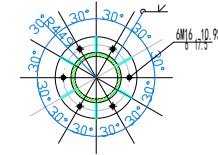


A-A 1:10

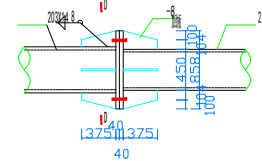


托架弦杆拼接节点示意 1:10

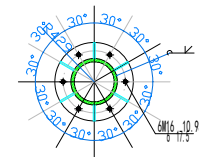


D-D 1:10

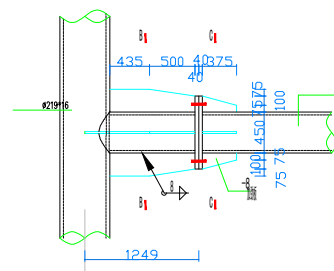

水平托架与钢柱连接节点示意 1:10



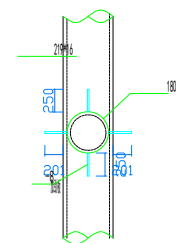


B-B 1:10

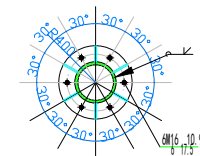


C-C 1:10

	注釋: 1.全部設計圖紙及說明之版權屬於本公司。 2.所示尺寸須由施工單位現場量檢為準。 3.圖紙與現場如有不一致之處均以圖紙設計為準。 4.單位: mm(如無特殊註明單位尺寸為毫米)。 NOTES 1. All the design plans and that the copyright of the Company without the consent of the Company,shall not be used, copied and reproduced. 2. Shown by the construction unit size, whichever is the scene review. 3. Drawings at the scene and if there are discrepancies, please notify the designer. 4. Unit: mm	展会名称 Exhibition Name	设计 Designer	制图日期 Date	展馆 Venve	图号 Drawing No.
		公司名称 Company Name	审核 Approved by	比例 Scale 	展位号 Hall No.	

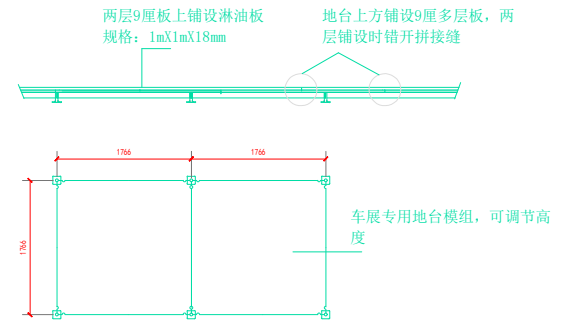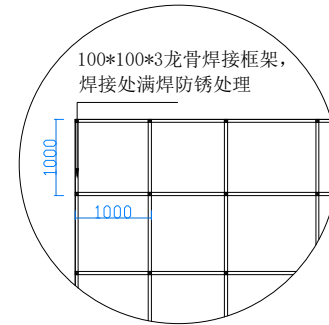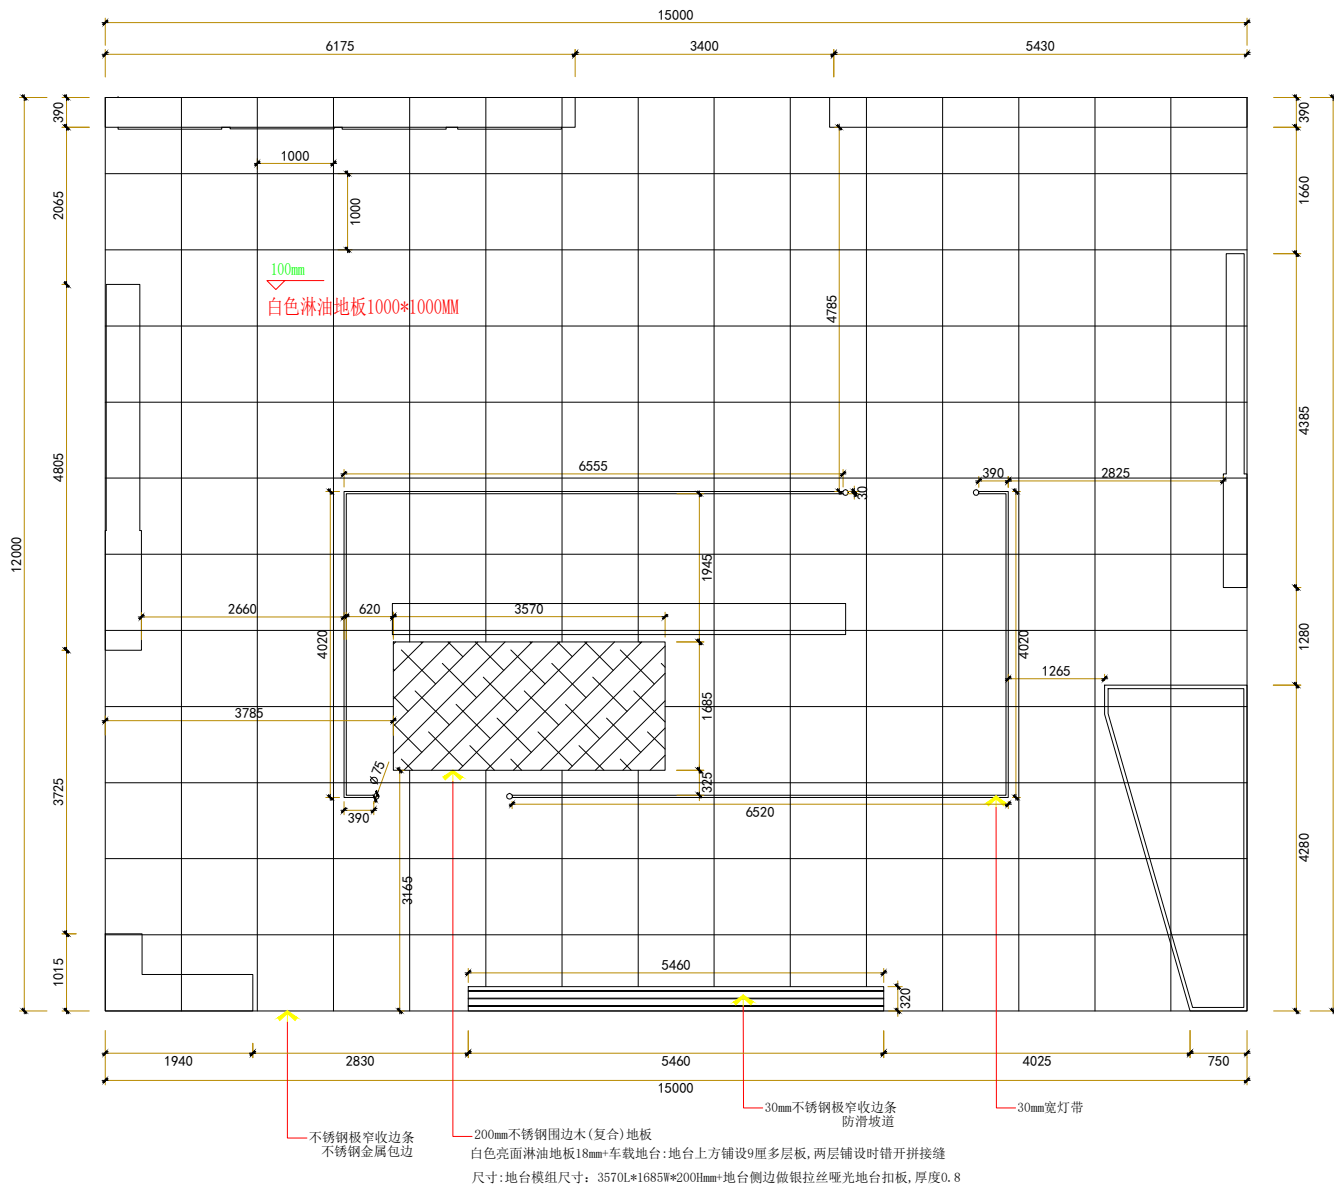


地面材质图
面积约180平方
H=6000mm

注释: 1. 全部设计图则及说明之版权属于本公司 2. 所示尺寸皆按施工单位现场量测为准 3. 圆角半径均按图中所示之尺寸标注(圆角半径) 4. 单位: mm(如无特殊注明单位均为毫米) NOTES 1. All the design plans and that the copyright of the Company without the consent of the Company shall not be used, copied and reproduced. 2. Shown by the construction unit size, whichever is the scene review. 3. Drawings at the scene and if there are discrepancies, please notify the designer. 4. Unit: mm	展会名称 Exhibition Name	燃气集团	设计 Designer	制图日期 Date	2026.07	展馆 Venne	图号 Drawing No.
	公司名称 Company Name		审核 Approved by	比例 Scale	A2	展位号 Hall No.	

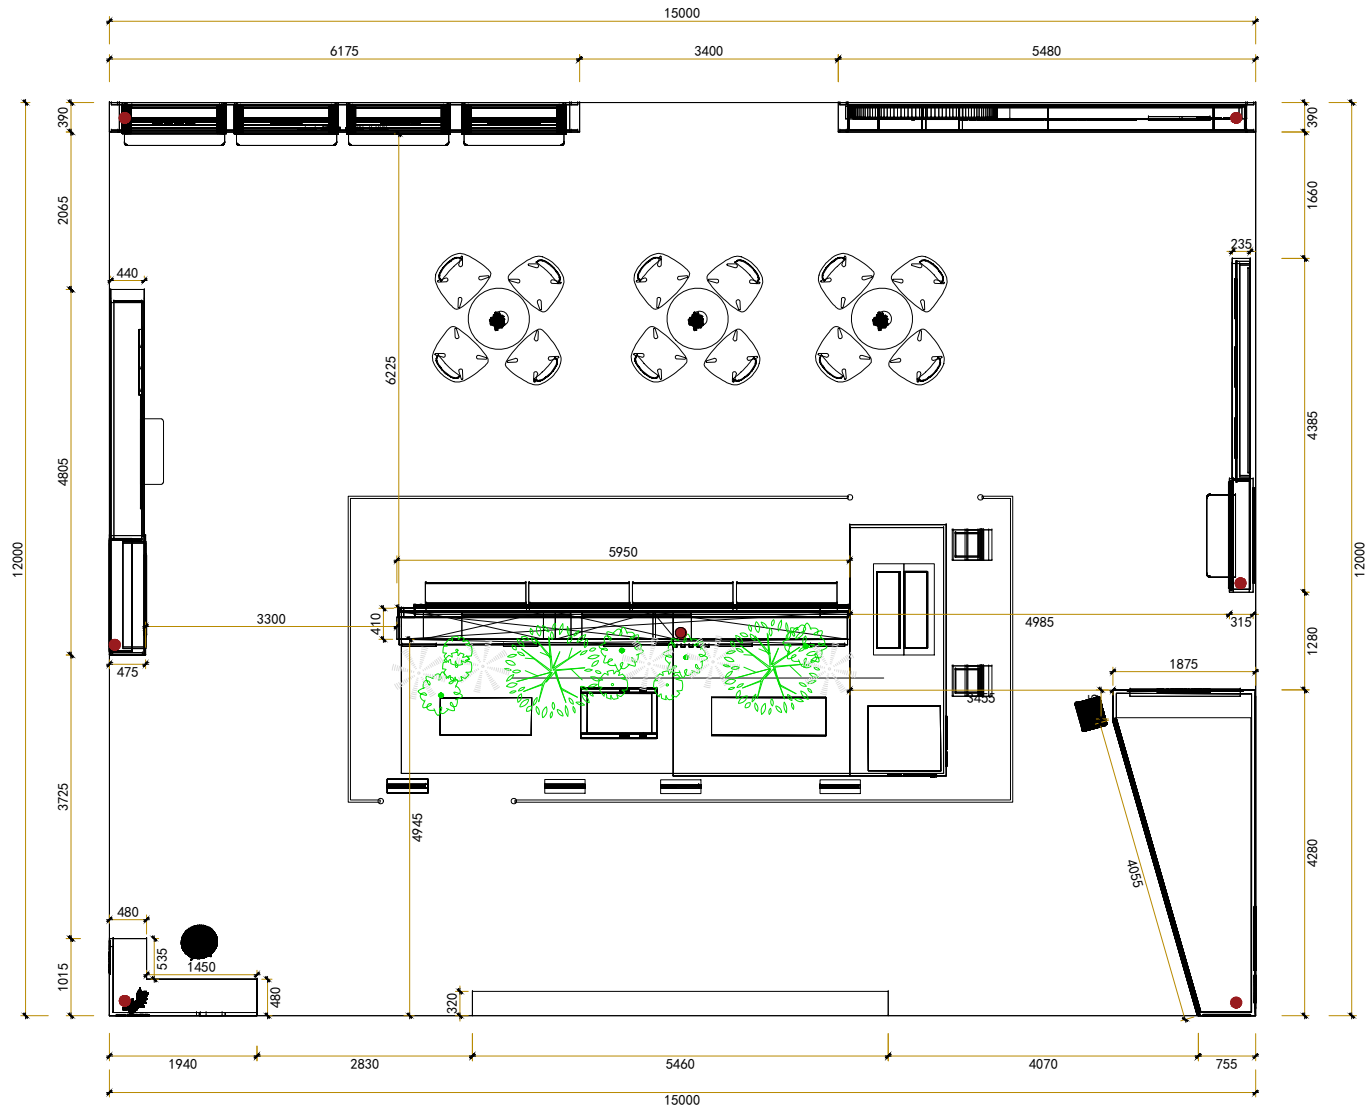


墙体尺寸放线图
1:60
面积约180平方
H=6000mm

注: 1.全部设计图则及说明之版权属于本公司 2.所示尺寸仅供参考,施工单位现场量取为准 3.面积若有误差,概与本公司无关,请设计师设计 4.单位: mm(如无特殊注明,单位均为毫米) NOTES 1. All the design plans and that the copyright of the Company without the consent of the Company, shall not be used, copied and reproduced. 2. Shown by the construction unit size, whichever is the scene review. 3. Drawings at the scene and if there are discrepancies, please notify the designer. 4. Unit: mm	展会名称 Exhibition Name	燃气集团	设计 Designer	制图日期 Date	2026.07	展馆 Venne	图号 Drawing No.
	公司名称 Company Name		审核 Approved by	比例 Scale	A2	展位号 Hall No.	

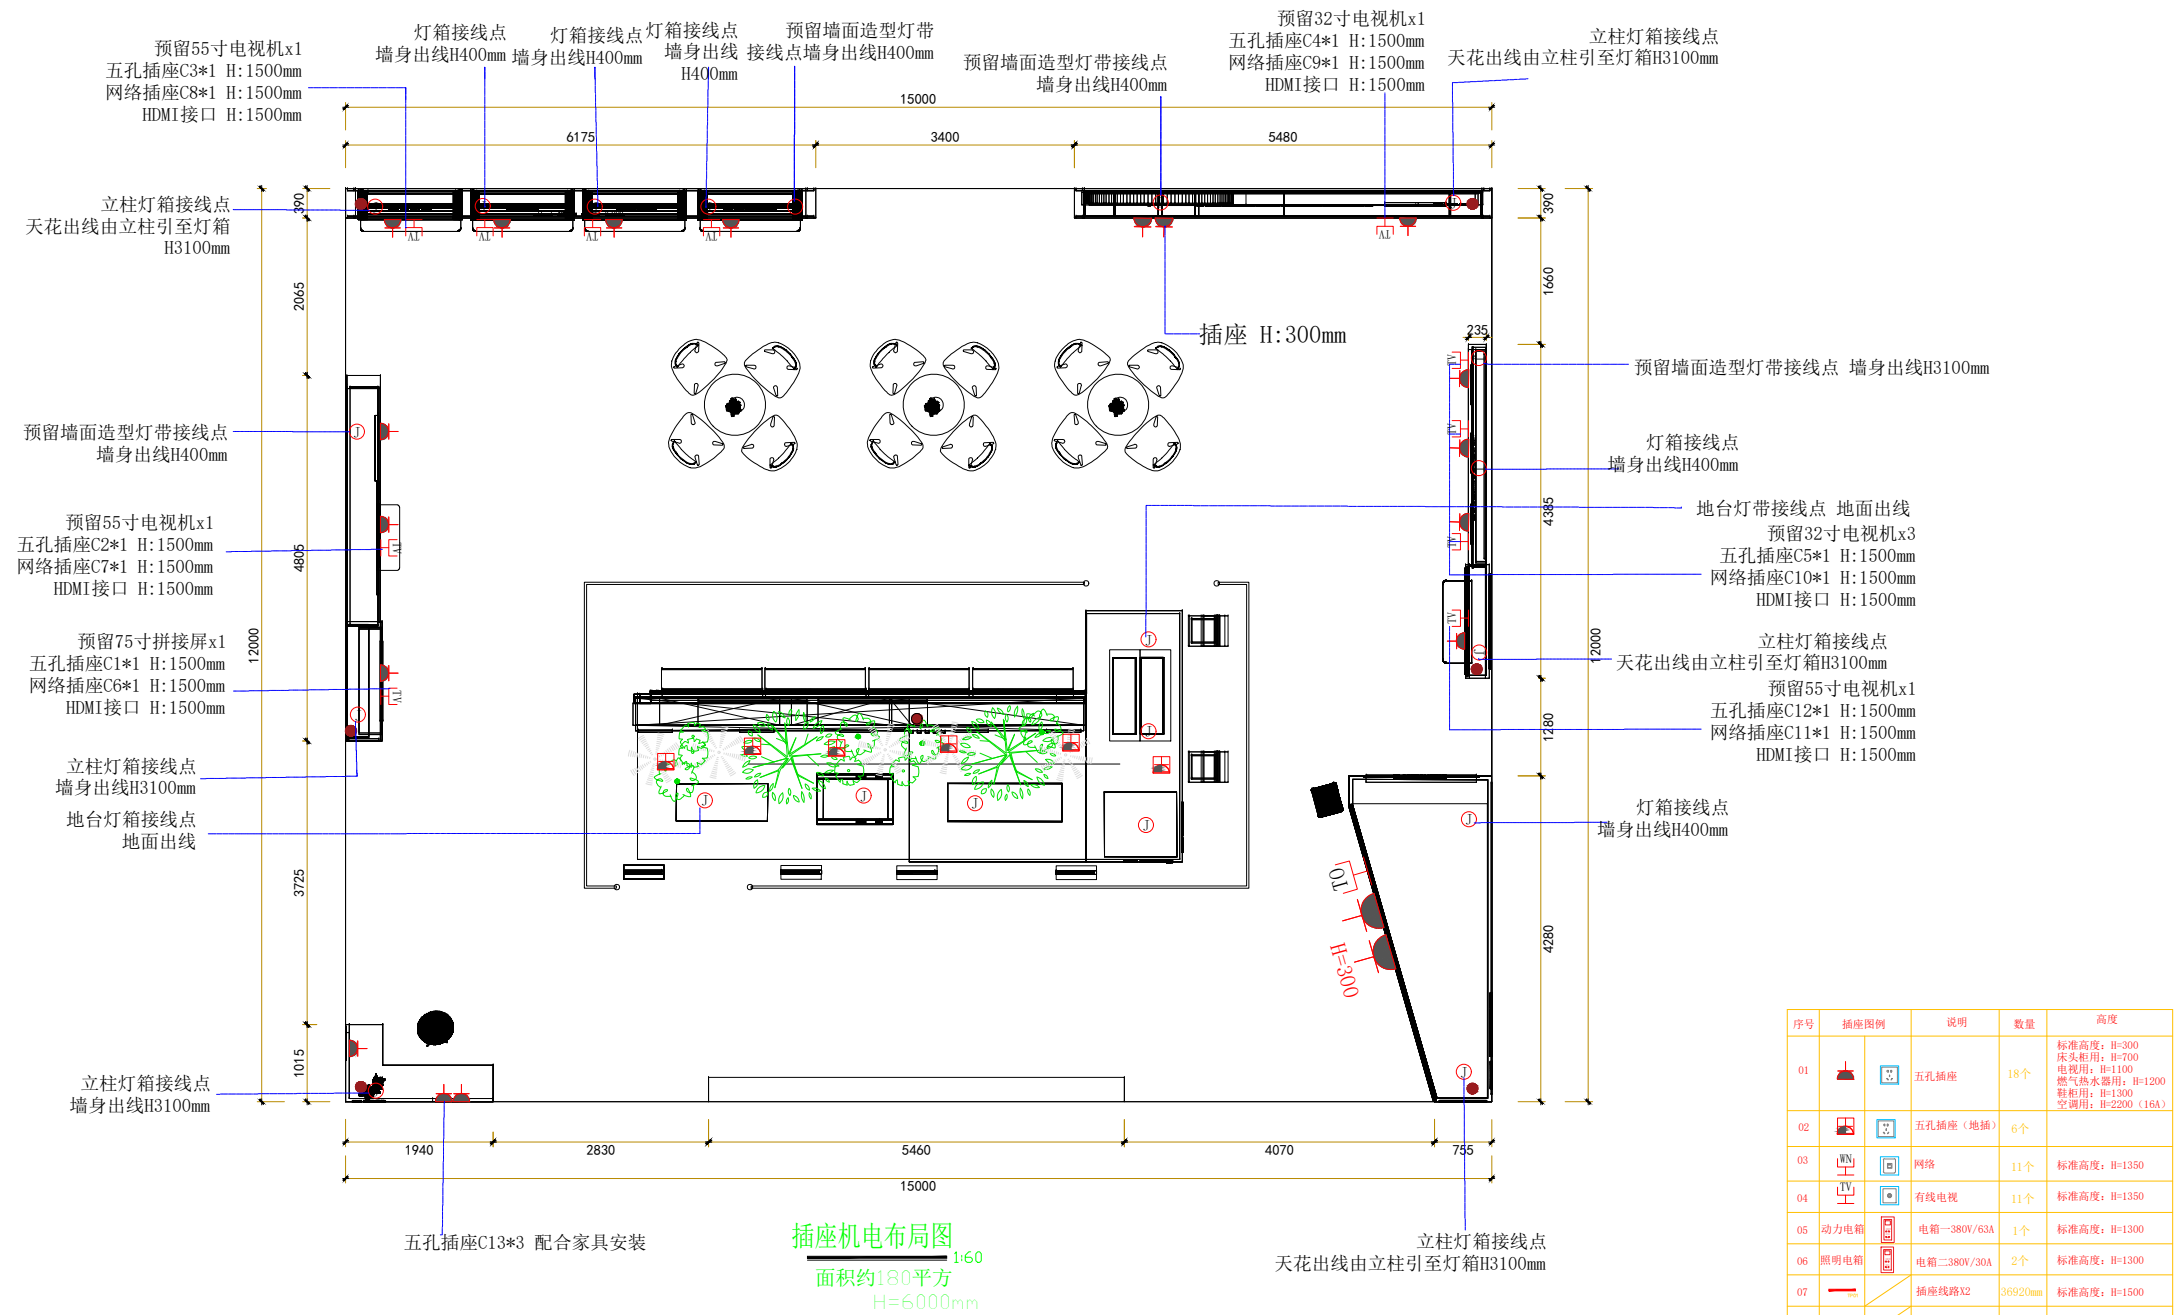


序号	插座图例	说明	数量	高度
01		五孔插座	18个	标准高度: H=300 床头柜用: H=700 电视用: H=1100 燃气热水器用: H=1200 鞋柜用: H=1300 空调用: H=2200 (16A)
02		五孔插座(地插)	6个	
03		网络	11个	标准高度: H=1350
04		有线电视	11个	标准高度: H=1350
05		配电箱-380V/63A	1个	标准高度: H=1300
06		配电箱-380V/30A	2个	标准高度: H=1300
07		插座线路X2	36920mm	标准高度: H=1500
08		TV电视线路X2	23055mm	标准高度: H=1500
09		LED屏幕线路	17235mm	标准高度: H=300
10		电线出现点	20个	

注: 1.全部设计图例及说明之版权属于本公司 2.所示尺寸由施工单位现场测量为准 3.图例及说明如有与本公司之标准图例不一致时,以本公司标准图例为准 4.单位: mm(如无特殊注明单位尺寸为毫米) NOTES 1. All the design plans and that the copyright of the Company without the consent of the Company shall not be used, copied and reproduced. 2. Shown by the construction unit size, whichever is the scene review. 3. Drawings at the scene and if there are discrepancies, please notify the designer. 4. Unit: mm	展会名称 Exhibition Name	燃气集团	设计 Designer	制图日期 Date	2026.07	展馆 Venne	图号 Drawing No.
	公司名称 Company Name		审核 Approved by	比例 Scale	A2	展位号 Hall No.	

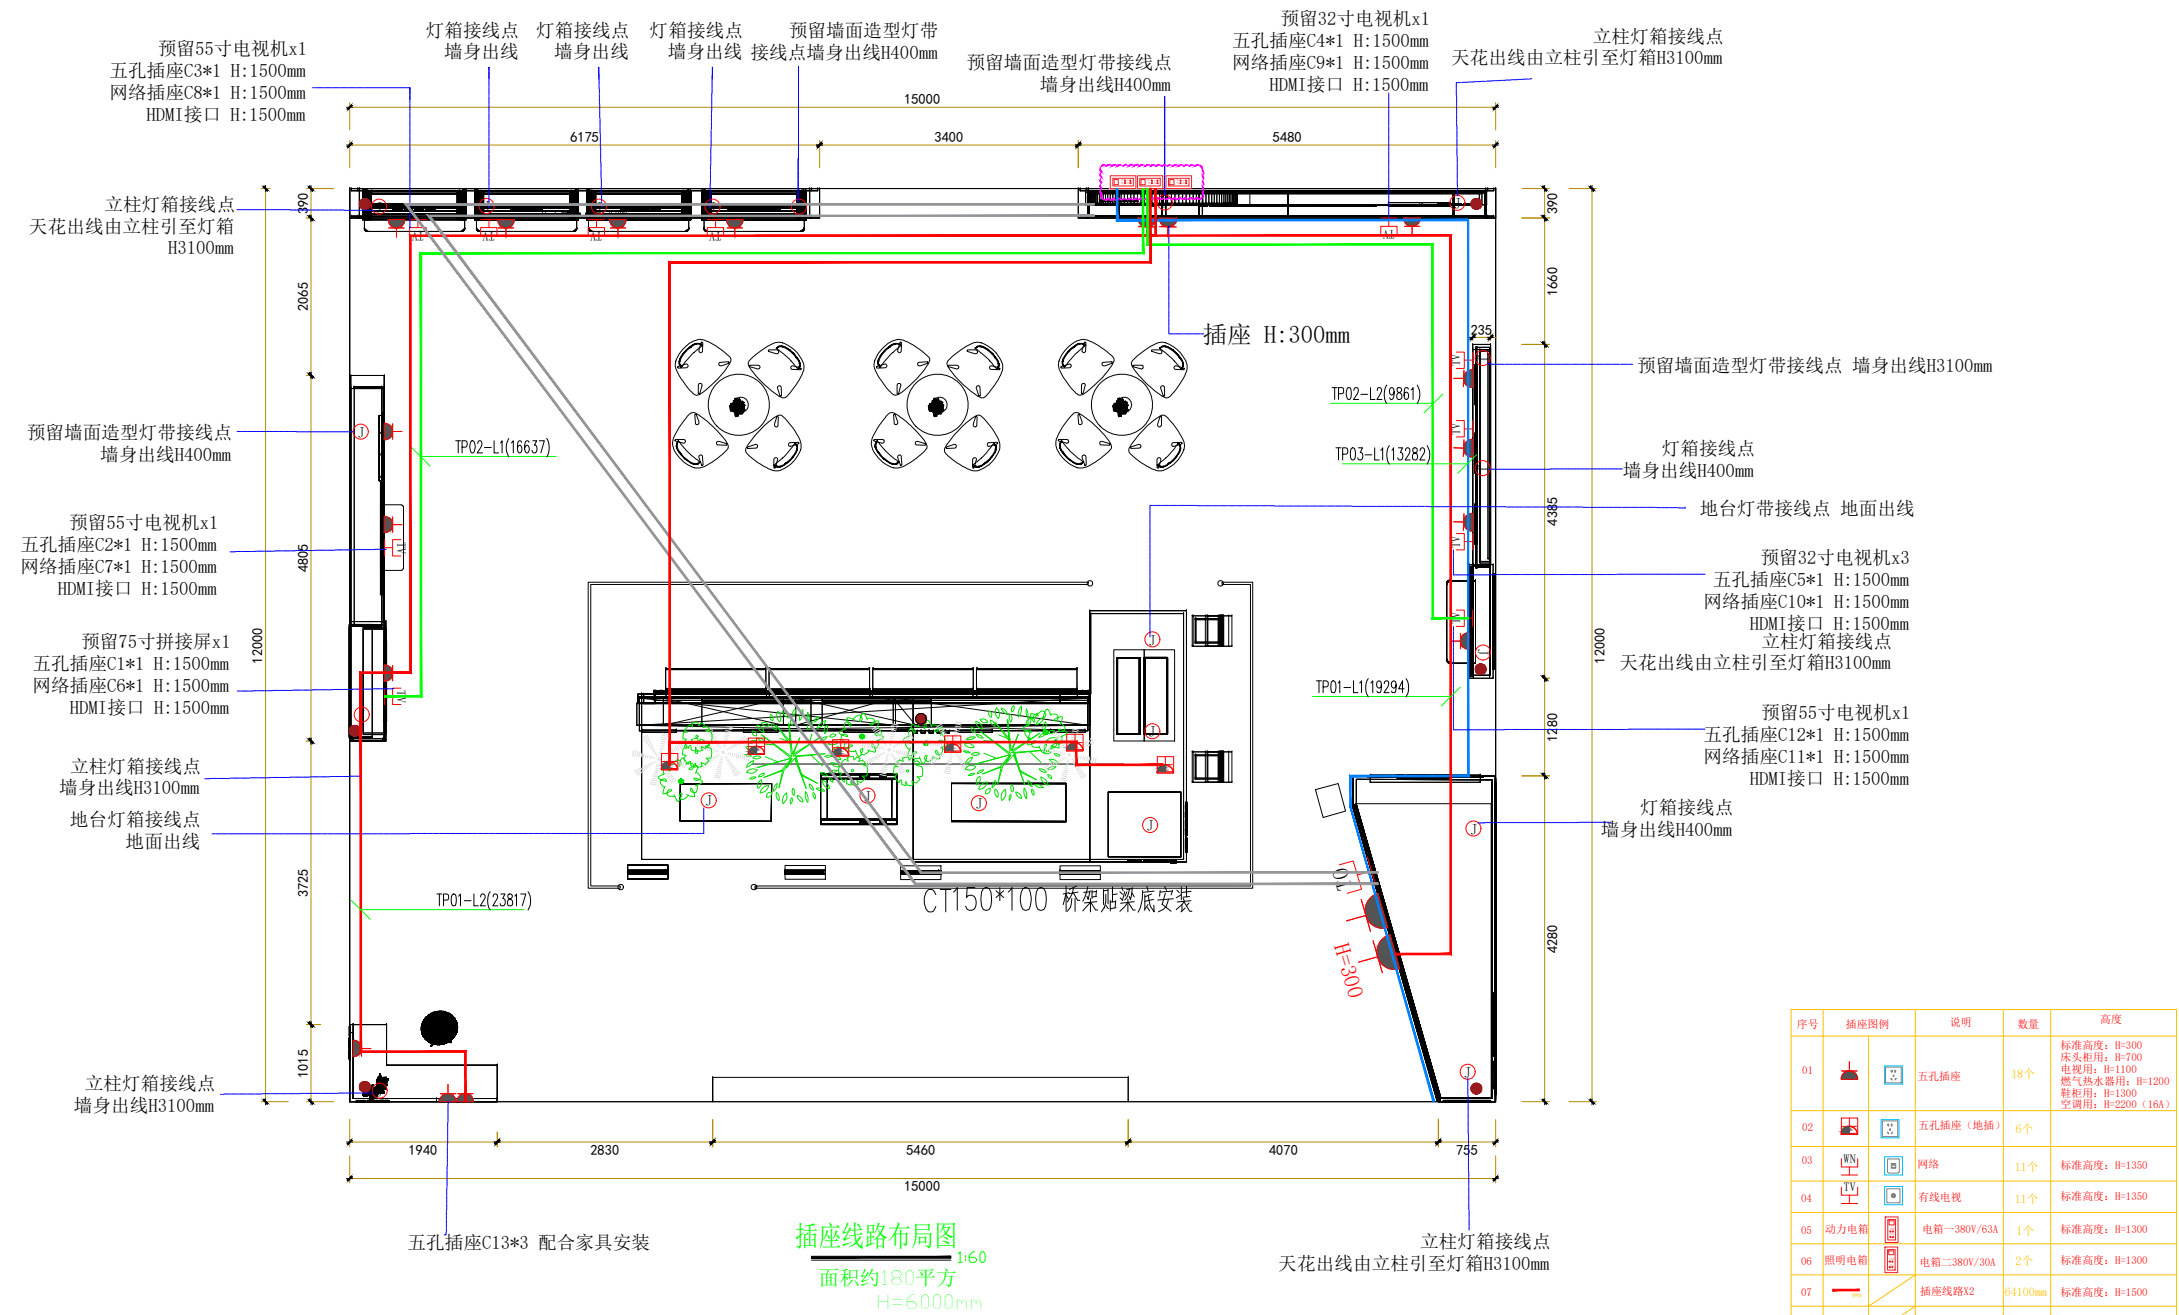


序号	插座图例	说明	数量	高度
01		五孔插座	18个	标准高度: H=300 床头柜用: H=700 电视用: H=1100 燃气热水器用: H=1200 空调用: H=2200 (16A)
02		五孔插座(地插)	6个	
03		网络	11个	标准高度: H=1350
04		有线电视	11个	标准高度: H=1350
05		电箱一380V/63A	1个	标准高度: H=1300
06		电箱二380V/30A	2个	标准高度: H=1300
07		插座线路X2	64100mm	标准高度: H=1500
08		TV电视线路X2	26498mm	标准高度: H=1500
09		LED屏幕线路	13282mm	标准高度: H=300
10		电线出现点	20个	

注: 1.全部设计图例及说明之版权属于本公司 2.所示尺寸由施工单位现场测量为准 3.图例符号与现场不符之处,以实际施工为准 4.单位: mm(如无特殊注明,单位均为毫米) NOTES 1. All the design plans and that the copyright of the Company without the consent of the Company, shall not be used, copied and reproduced. 2. Shown by the construction unit size, whichever is the scene review. 3. Drawings at the scene and if there are discrepancies, please notify the designer. 4. Unit: mm	展会名称 Exhibition Name	燃气集团	设计 Designer	制图日期 Date	2026.07	展馆 Venne	图号 Drawing No.
	公司名称 Company Name		审核 Approved by	比例 Scale	A2	展位号 Hall No.	

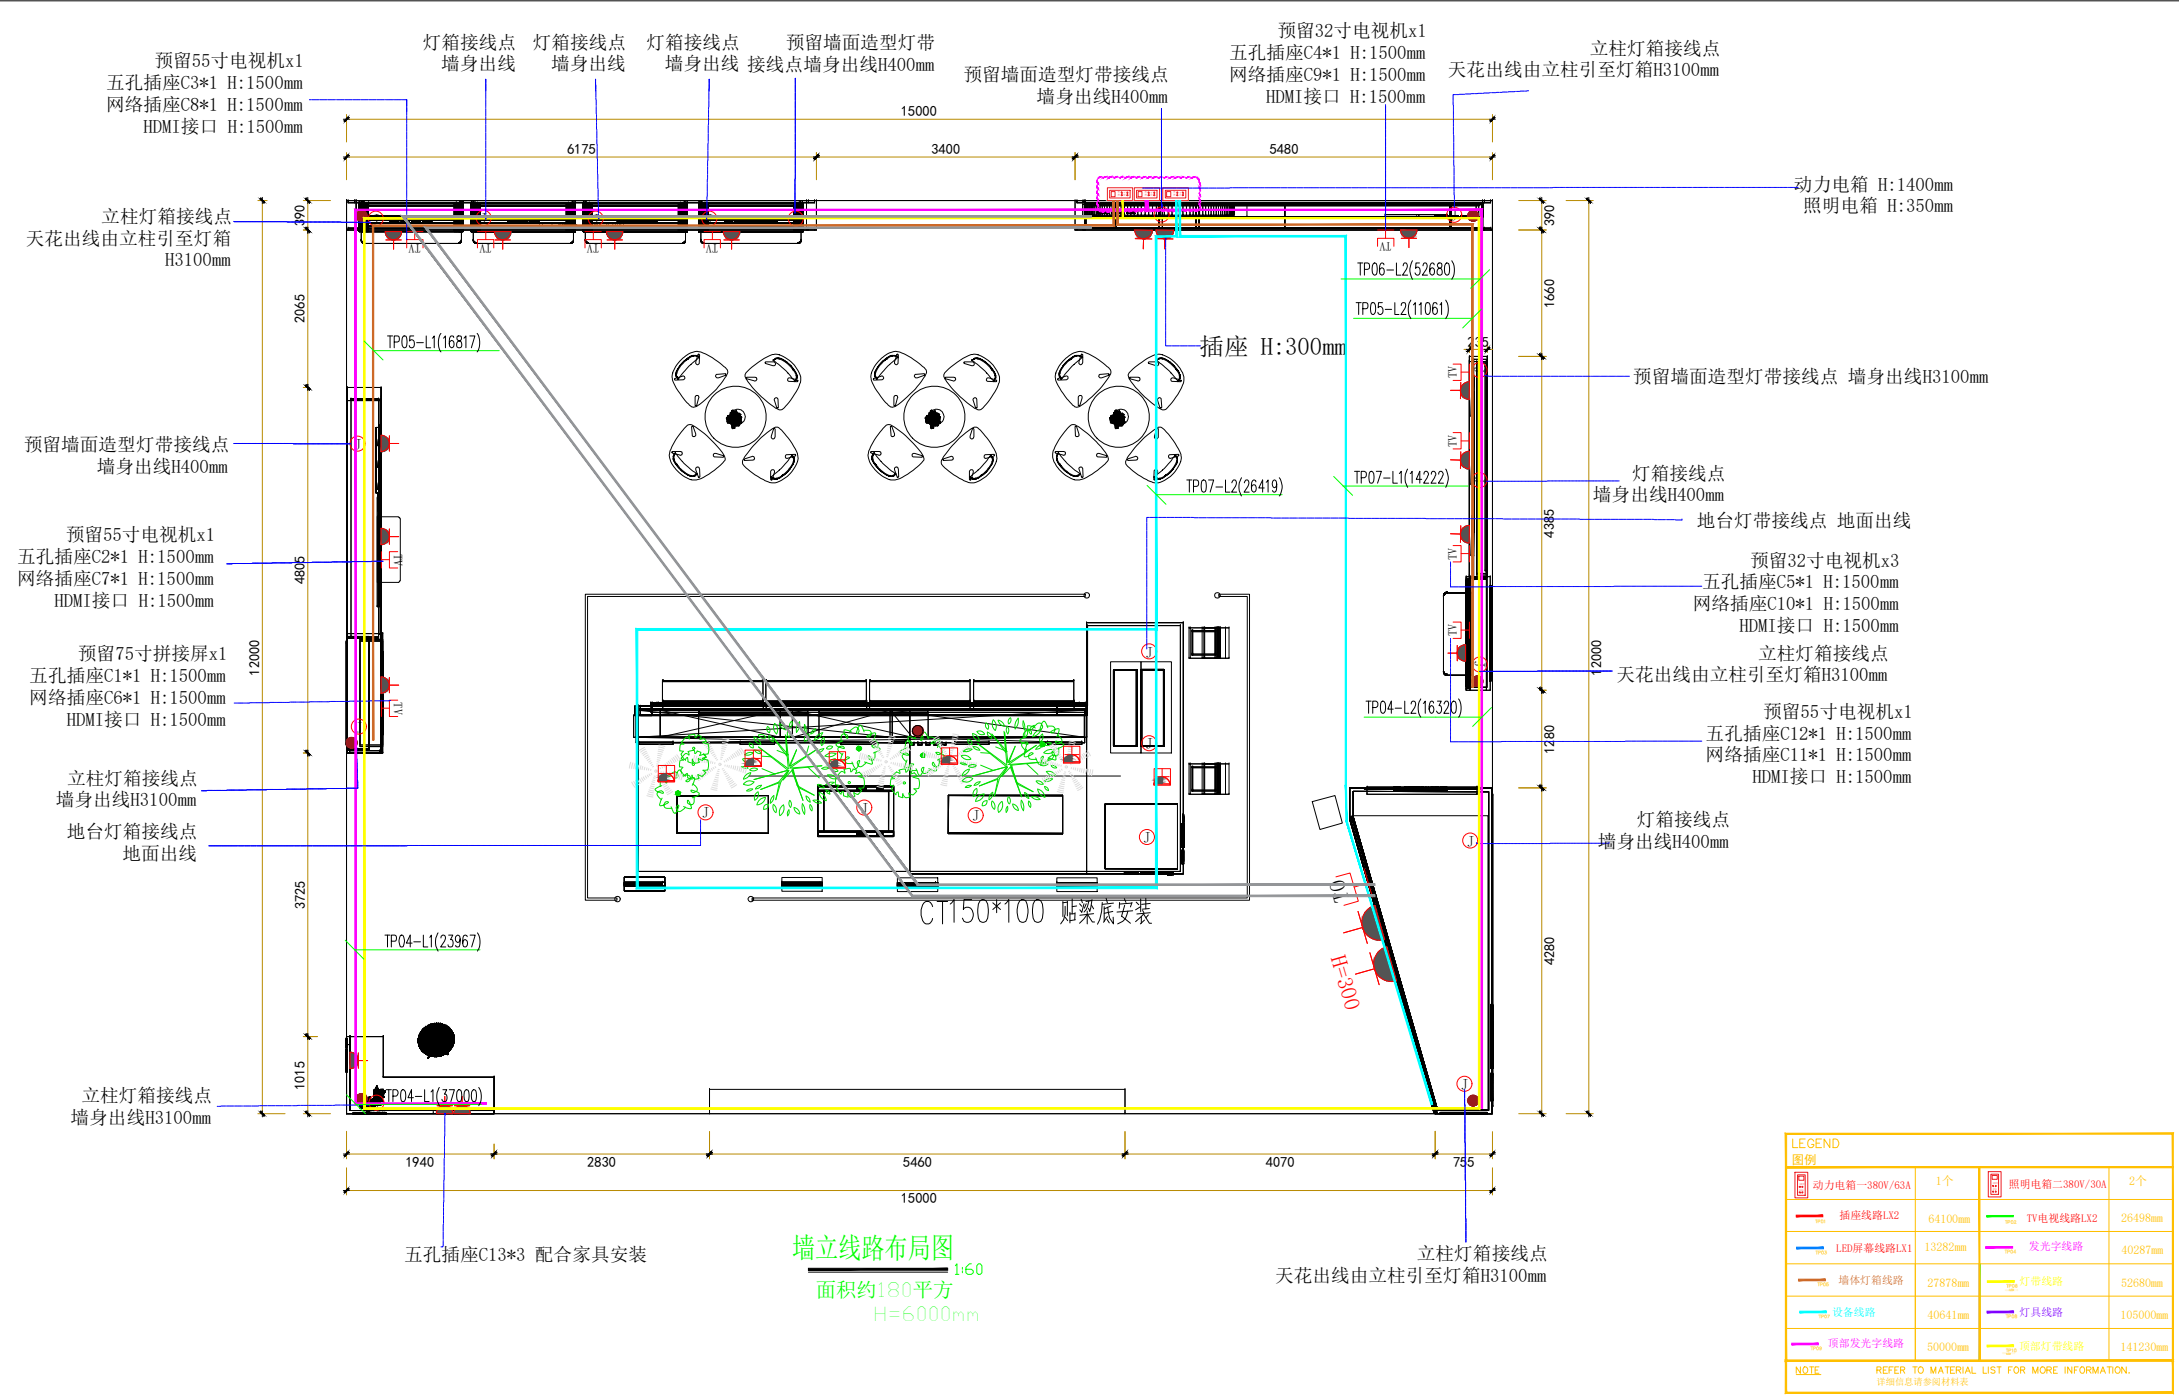


注: 1.全部设计图则及说明之版权属于本公司 2.所示尺寸由施工单位现场测量为准 3.图纸如有与现场不符之处,以现场实际情况为准 4.单位: mm(如无特殊注明,单位均为毫米) NOTES 1. All the design plans and that the copyright of the Company without the consent of the Company, shall not be used, copied and reproduced. 2. Shown by the construction unit size, whichever is the scene review. 3. Drawings at the scene and if there are discrepancies, please notify the designer. 4. Unit: mm	展会名称 Exhibition Name	燃气集团	设计 Designer	制图日期 Date	2026.07	展馆 Venne	图号 Drawing No.
	公司名称 Company Name		审核 Approved by	比例 Scale	A2	展位号 Hall No.	

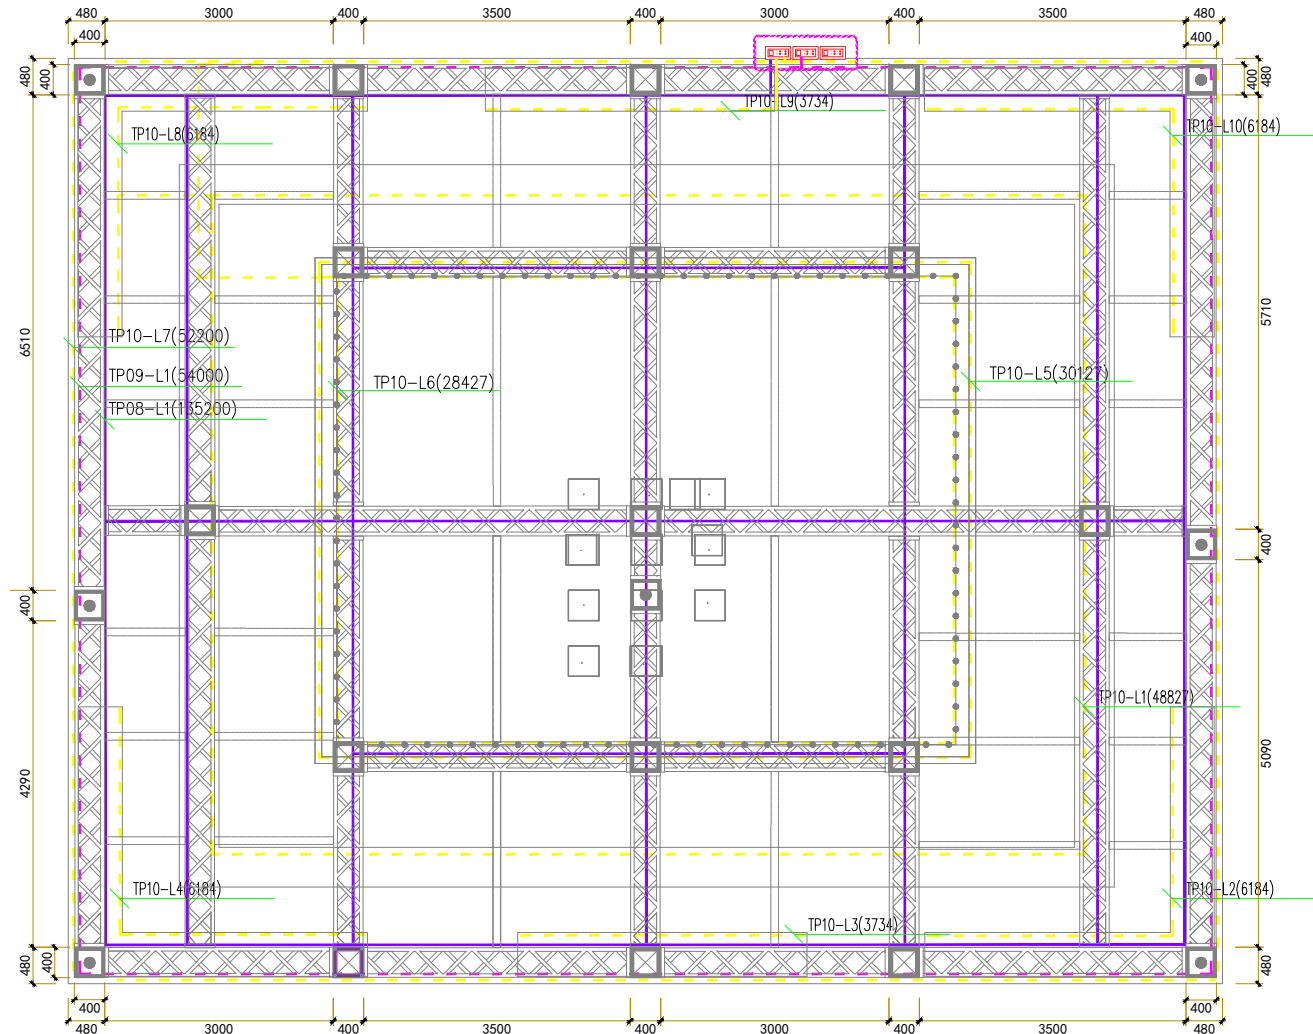

天花线路布置图
面积约180平方
H=6000mm

LEGEND					
图例					
	动力电箱—380V/63A	1个		照明电箱二380V/30A	2个
	插座线路LX2	64100mm		TV电视线路LX2	23055mm
	LED屏幕线路LX1	17235mm		发光线路	39265mm
	墙体灯箱线路	26230mm		灯带线路	50000mm
	设备线路	37318mm		灯具线路	135200mm
	顶部发光线路	54000mm		顶部灯带线路	192000mm
NOTE REFER TO MATERIAL LIST FOR MORE INFORMATION. 详细信息请参阅材料表					

注释: 1.全部设计图例及说明之版权属于本公司 2.所示尺寸均为施工单位现场量测为准 3.制图者/审核者/审批者之姓名/日期/设计/ 4.单位: mm(如无特殊注明单位尺寸为毫米) NOTES 1. All the design plans and that the copyright of the Company without the consent of the Company, shall not be used, copied and reproduced. 2. Shown by the construction unit size, whichever is the scene review. 3. Drawings at the scene and if there are discrepancies, please notify the designer. 4. Unit: mm	展会名称 Exhibition Name	燃气集团	设计 Designer	制图日期 Date	2026.07	展馆 Venve	图号 Drawing No.
	公司名称 Company Name		审核 Approved by	比例 Scale	A2	展位号 Hall No.	

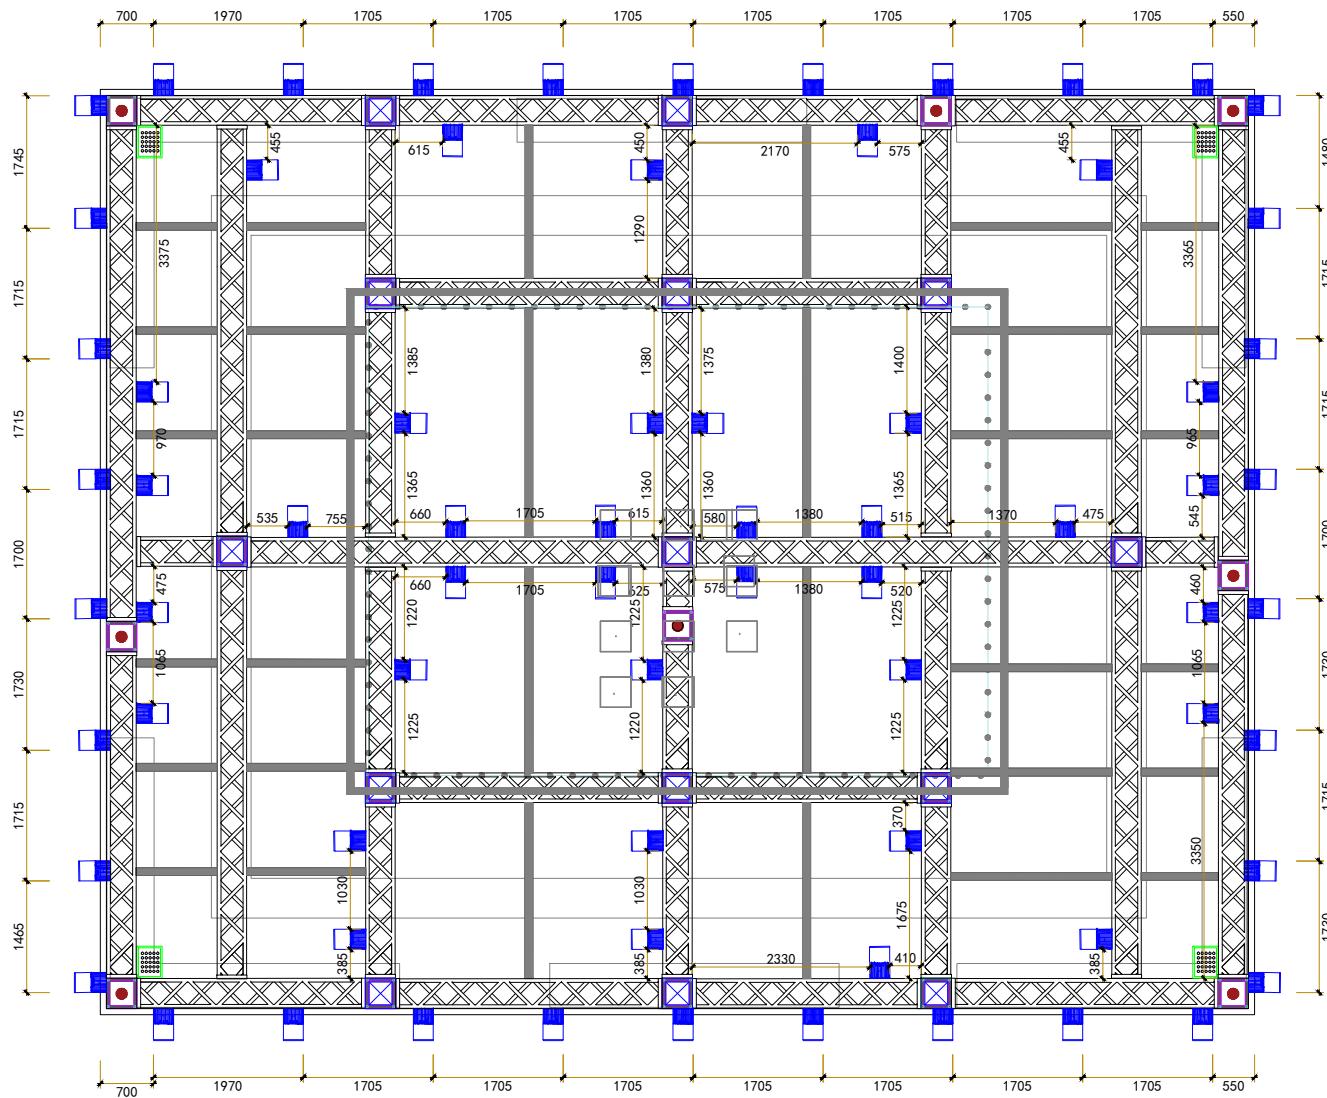


天花灯定位图
面积约180平方
H=6000mm

LEGEND					
图例					
	动力电箱—380V/63A	1个		照明电箱二380V/30A	2个
	车展灯H6000mm	73个		音响H6000mm	4个
	插座线路LX2	36920mm		TV电视线路LX2	23055mm
	LED屏幕线路LX1	17235mm		发光线路	39265mm
	墙体灯箱线路	20230mm		灯带线路	50000mm
	设备线路	37318mm		灯具线路	135200mm
	顶部发光线路	54000mm		顶部灯带线路	192000mm
NOTE: REFER TO MATERIAL LIST FOR MORE INFORMATION. 详细信息请参阅材料表					

注: 1.全部设计图例及说明之版权属于本公司 2.所示尺寸均为施工现场单位现场量测为准 3.如有变更或修改之处,请及时通知设计 4.单位: mm(如无特殊注明,单位均为毫米) NOTES 1. All the design plans and that the copyright of the Company without the consent of the Company, shall not be used, copied and reproduced. 2. Shown by the construction unit size, whichever is the scene review. 3. Drawings at the scene and if there are discrepancies, please notify the designer. 4. Unit: mm	展会名称 Exhibition Name 燃气集团	设计 Designer	制图日期 Date 2026.07	展馆 Venue	图号 Drawing No.
	公司名称 Company Name	审核 Approved by	比例 Scale A2	展位号 Hall No.	


电路设计及施 说明：

- 1、本特装展位 电必须采 有漏电保护的空 开关作保护
- 2、电线敷设采 难燃双塑铜芯线或护套电线，套难燃的PVC塑料线管或 属管保护，灯具引接采 属软管作保护。
- 3、地 和地板暗敷电线要求 属管保护。

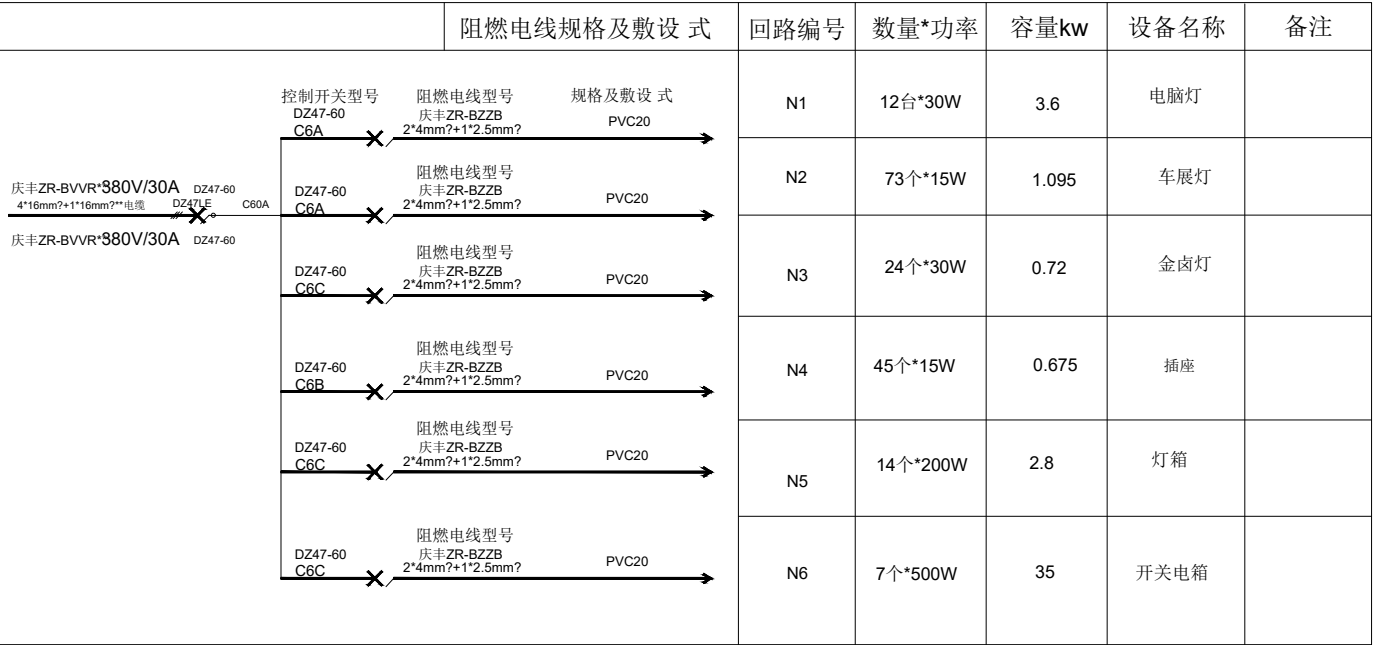


分部分项工程量清单

序号	图 例	设备器材名称	项目特征描述	计量 单位	工程量	间 距 (M)	安装高度(M)
1		P2.5LED拼接屏	(1)名称:P2.5LED拼接屏 (2)规格:P2.5 (3)包含安装、保护性拆除及租赁费,其他具体要求详见图纸、招标文件、技术要求及相关规范	m2	70.5		结合建施
2		P2拼接屏	(1)名称:LED拼接屏 (2)规格:P2 (3)包含安装、保护性拆除及租赁费,其他具体要求详见图纸、招标文件、技术要求及相关规范	m2	43.9		结合建施
3		播控主机	(1)名称:播控主机 (2)包含安装、保护性拆除及租赁费,其他具体要求详见图纸、招标文件、技术要求及相关规范	套	6		结合建施
4		背景音乐系统设备	(1)名称:普通音响 (2)包含安装、保护性拆除及租赁费,其他具体要求详见图纸、招标文件、技术要求及相关规范	台	6		结合建施
5		扩声系统设备	(1)名称:挂耳式扩音器 (2)包含安装、保护性拆除及租赁费,其他具体要求详见图纸、招标文件、技术要求及相关规范	个	15		结合建施
6		扩声系统设备	(1)名称:手持数字麦克风 (2)包含安装、保护性拆除及租赁费,其他具体要求详见图纸、招标文件、技术要求及相关规范	个	8		结合建施
7		扩声系统设备	(1)名称:m32调音台 (2)包含安装、保护性拆除及租赁费,其他具体要求详见图纸、招标文件、技术要求及相关规范	台	8		结合建施
8		有线电视系统管理设备	(1)名称:55寸触摸屏 (2)屏幕比例:16:9接口类型:其他/other AV HDMI VGA 耳机接口 USB/分辨率:1920x1080/操作系统:安卓 (3)包含安装、保护性拆除及租赁费,其他具体要求详见图纸、招标文件、技术要求及相关规范	台	10		结合建施
9		有线电视系统管理设备	(1)名称:42寸触摸屏 (2)屏幕比例:16:9接口类型:其他/other AV HDMI VGA 耳机接口 USB/分辨率:1920x1080/操作系统:安卓 (3)包含安装、保护性拆除及租赁费,其他具体要求详见图纸、招标文件、技术要求及相关规范	台	3		结合建施
10		配电箱	(1)名称:配电箱 (2)规格:P13.86KW,含漏电保护器 (3)包含安装、保护性拆除及租赁费,其他具体要求详见图纸、招标文件、技术要求及相关规范	台	6		结合建施
11		电料	(1)名称:电料(0.57 规格国际六类网 线(控制及备份);音 响线;USB3.0 线缆;阻燃 PVC 线管 线槽; 工程扎带等) (2)含开关插座、插排 (3)电线均需:穿阻燃国际包塑金属软管加厚16mm; (4)使用电线:国标纯铜二芯电源线	项	1		结合建施
12		配管	c(1)名称:55寸触摸屏 (2)屏幕比例:16:9接口类型:其他/other AV HDMI VGA 耳机接口 USB/分辨率:1920x1080/操作系统:安卓 (3)包含安装、保护性拆除及租赁费,其他具体要求详见图纸、招标文件、技术要求及相关规范	m	150		结合建施
13		配线	(1)名称:配线 (2)规格:ZR-RVV-5*16mm2 (3)包含安装、保护性拆除及租赁费,其他具体要求详见图纸、招标文件、技术要求及相关规范	m	800		结合建施
14		电力电缆	(1)名称:电力电缆 (2)型号:ZR-YJV-4*50+1*25mm2 (3)包含安装、保护性拆除及租赁费,其他具体要求详见图纸、招标文件、技术要求及相关规范	m	490		结合建施
15		配电箱	(1)二级配电箱(P2.39KW) (2)含漏电保护器 (3)包含安装、保护性拆除及租赁费,其他具体要求详见图纸、招标文件、技术要求及相关规范	台	8		结合建施
16		电力电缆头	(1)电力电缆头制安50mm2以下 (2)包含安装、保护性拆除及租赁费,其他具体要求详见图纸、招标文件、技术要求及相关规范	个	16		结合建施
13		送配电装置系统	1.1kV以下交流供电系统调试	系统	3		结合建施
14		插座	(1)插座 (2)包含安装、保护性拆除及租赁费,其他具体要求详见图纸、招标文件、技术要求及相关规范	个	45		结合建施
15		灭火器	(1)干粉灭火器 (2)包含安装、保护性拆除及租赁费,其他具体要求详见图纸、招标文件、技术要求及相关规范	具	24		结合建施
16		LED灯带	(1)名称:LED灯带 (2)型号:单色 (3)包含安装、保护性拆除及租赁费,其他具体要求详见图纸、招标文件、技术要求及相关规范(2)包含安装、保护性拆除及租赁费,其他具体要求详见图纸、招标文件、技术要求及相关规范				

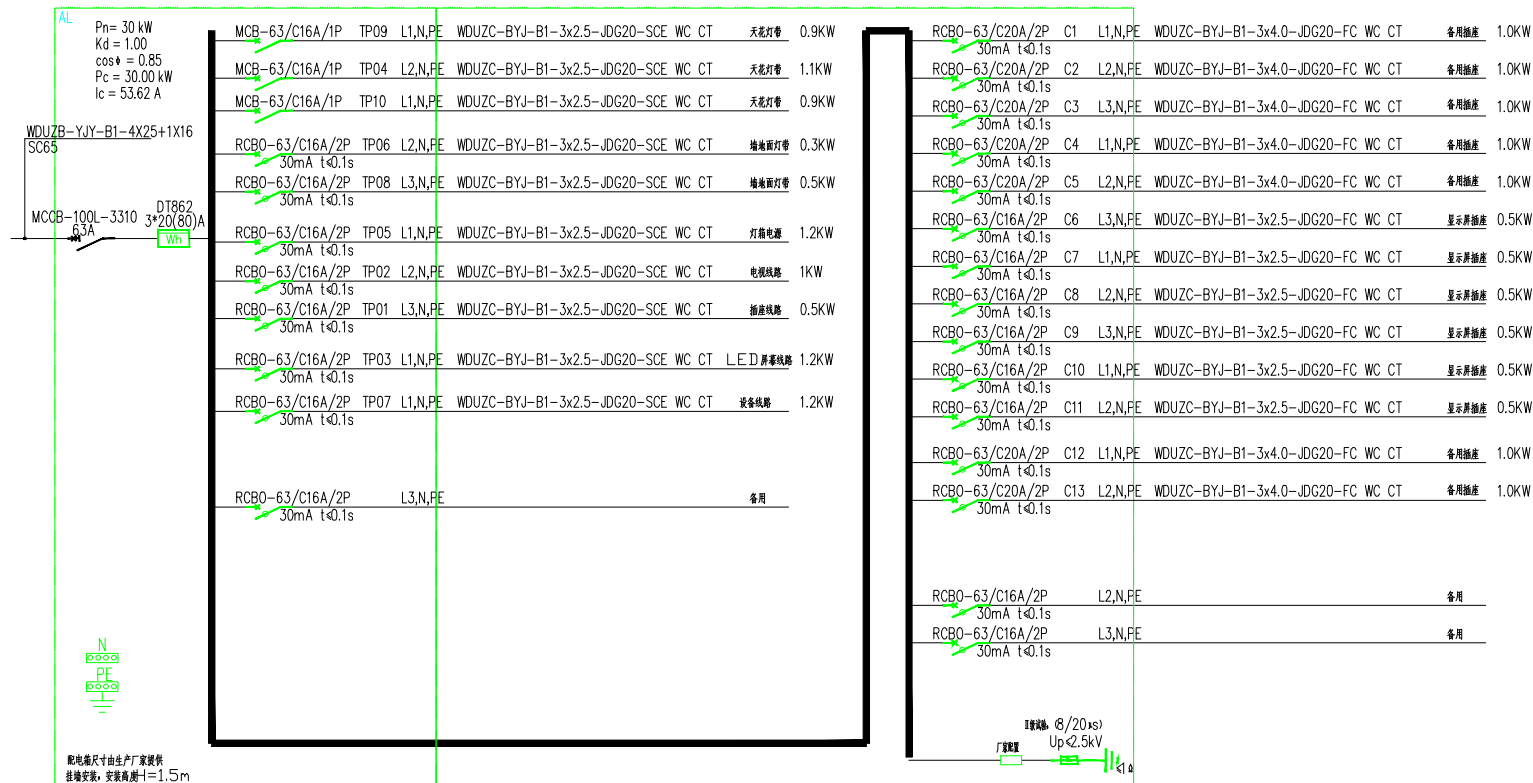

配电箱系统图

注: 1.全部设计图例及说明之版权属于本公司。 2.所示尺寸由施工图工单位现场量取为准。 3.图例说明与现场不符之处由施工图工单位负责。 4.单位: mm(如无特殊注明单位尺寸为毫米)。 NOTES 1. All the design plans and that the copyright of the Company without the consent of the Company shall not be used, copied and reproduced. 2. Shown by the construction unit size, whichever is the scene review. 3. Drawings at the scene and if there are discrepancies, please notify the designer. 4. Unit: mm	展会名称 Exhibition Name	燃气集团	设计 Designer	制图日期 Date	2026.07	展馆 Venve	图号 Drawing No.
	公司名称 Company Name		审核 Approved by	比例 Scale	A2	展位号 Hall No.	

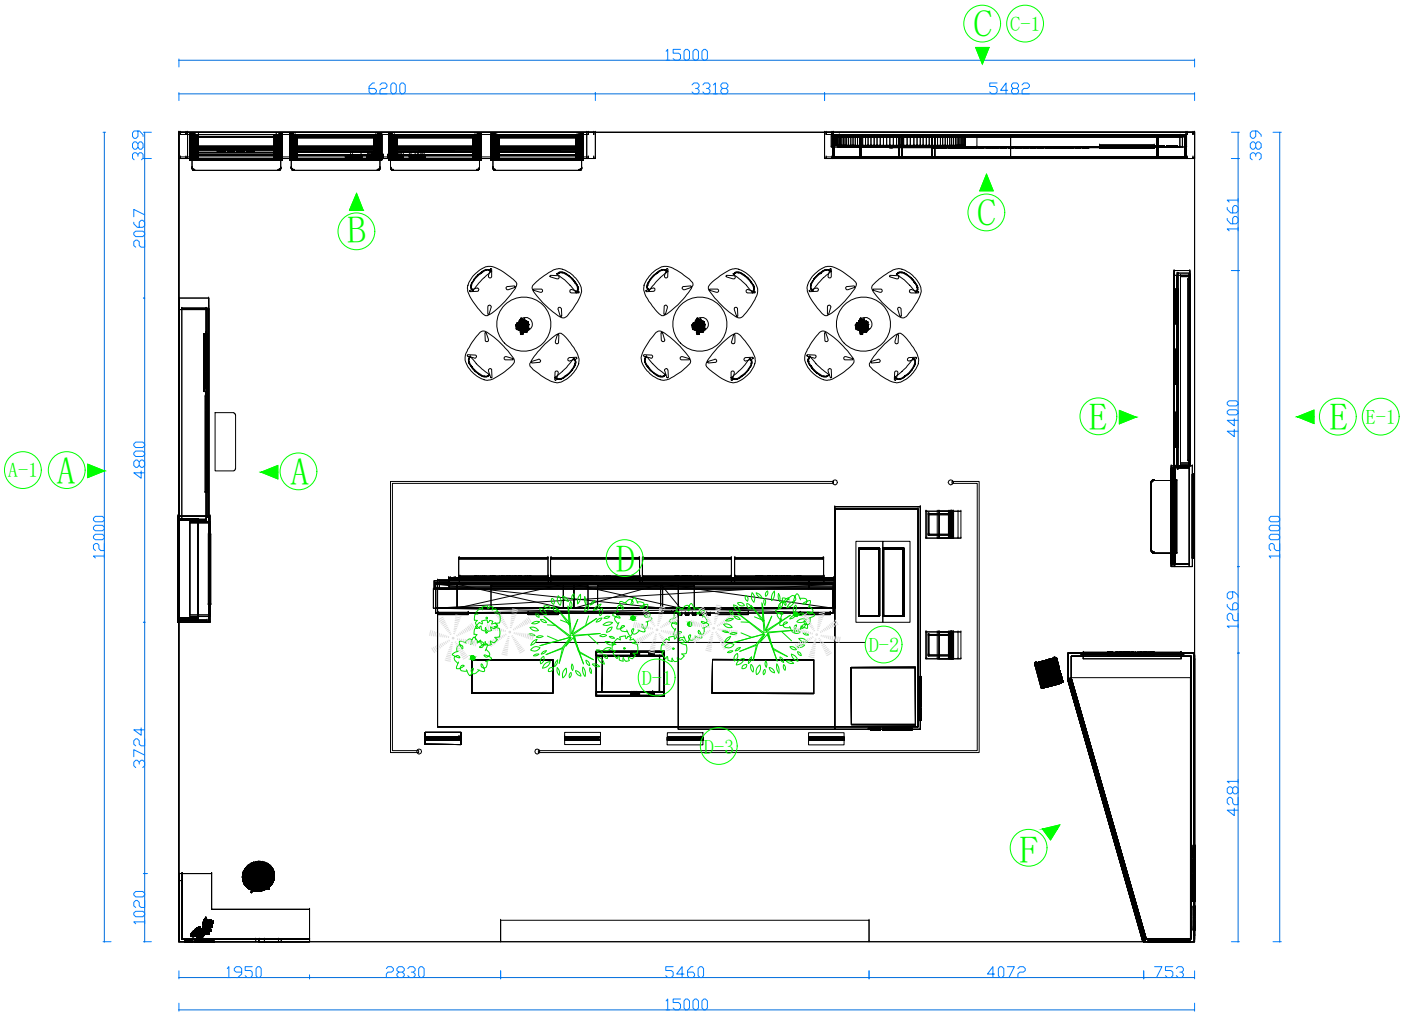


单位: mm

注释: 1.全部设计图则及说明之版权属于本公司 2.所示尺寸皆由施工单位现场量测为准 3.图则若有与现场不符之处,应以现场设计为准 4.单位: mm(如无特殊注明,单位均为毫米) NOTES 1. All the design plans and that the copyright of the Company without the consent of the Company, shall not be used, copied and reproduced. 2. Shown by the construction unit size, whichever is the scene review. 3. Drawings at the scene and if there are discrepancies, please notify the designer. 4. Unit: mm	展会名称 Exhibition Name	设计 Designer	制图日期 Date 2026.07.27	展馆 Venue	图号 Drawing No.
	公司名称 Company Name 深圳燃气集团	审核 Approved by	比例 Scale A3 1:30	展位号 Hall No.	


背墙A

该图为设计图纸，必须按图纸内所预留设计尺寸空间，如现场有变动或尺寸有调整，必需提前以文字形式通知设计师修改。

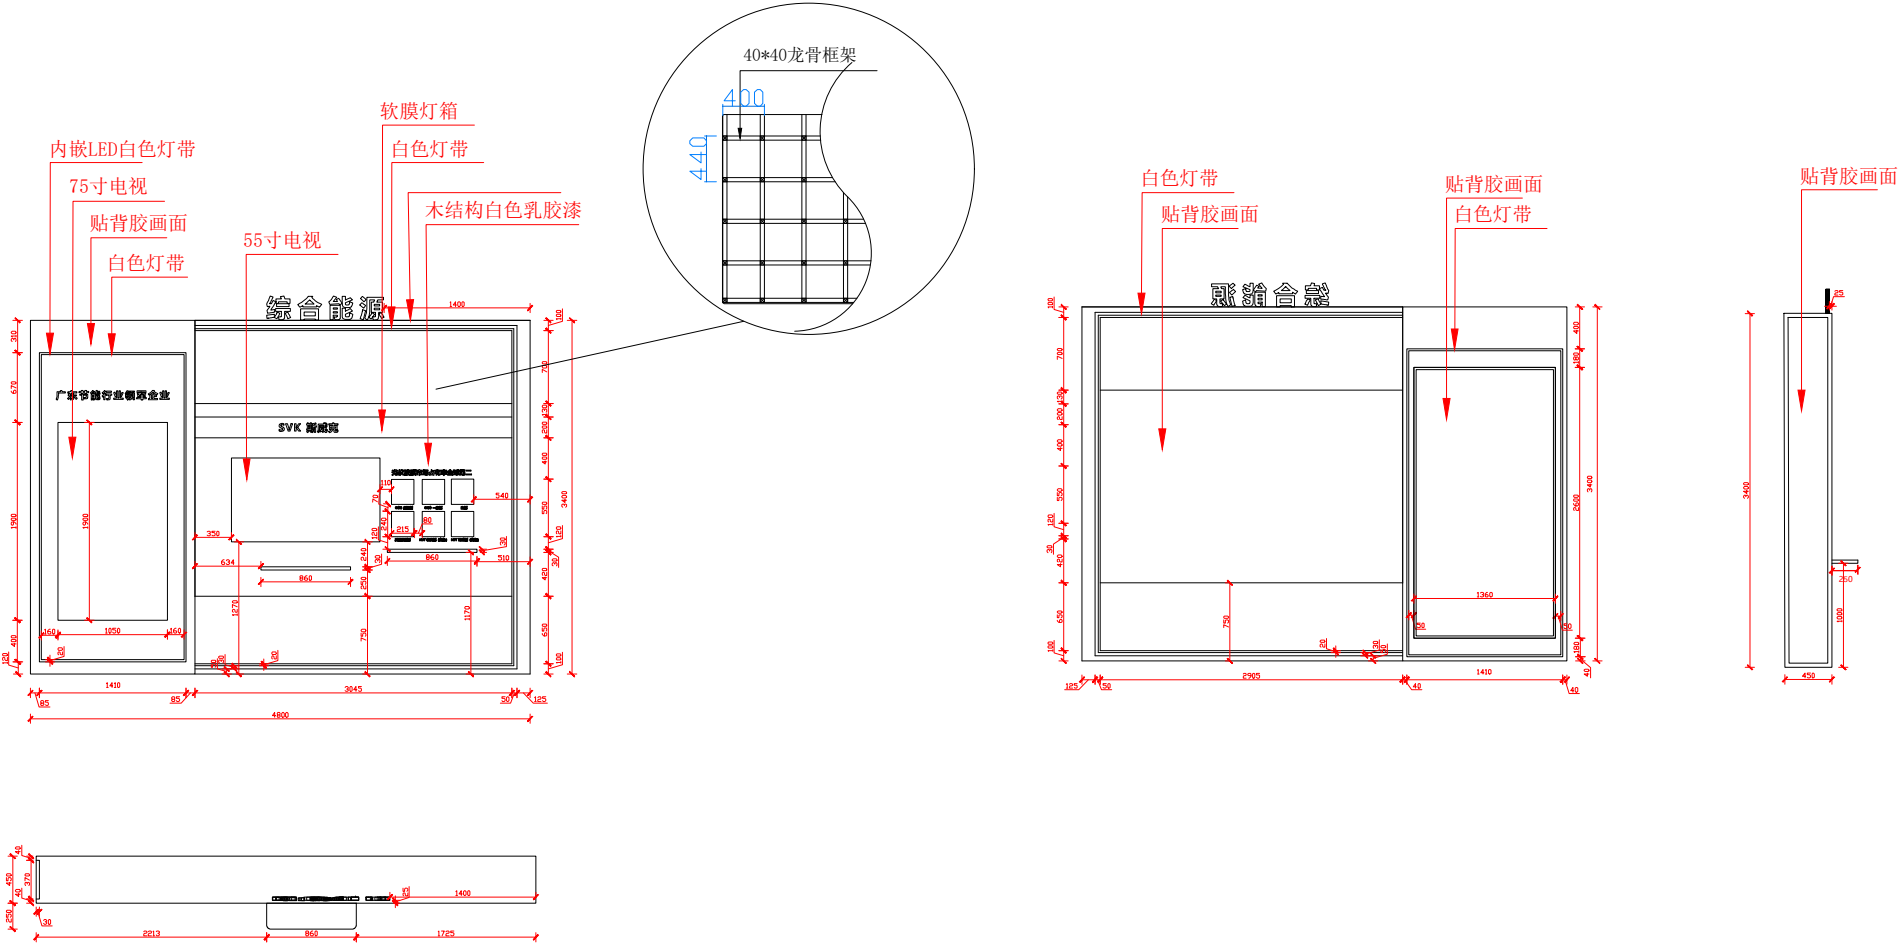

单位: mm

注释: 1. 全部设计图例及说明之版权属于本公司 2. 所示尺寸仅供参考, 施工单位现场量取为准 3. 图纸如有错误或矛盾之处, 以最新出图为准 4. 单位: mm (如无特殊注明, 单位均为毫米) NOTES 1. All the design plans and that the copyright of the Company without the consent of the Company, shall not be used, copied and reproduced. 2. Shown by the construction unit size, whichever is the scene review. 3. Drawings at the scene and if there are discrepancies, please notify the designer. 4. Unit: mm	展会名称 Exhibition Name	设计 Designer	制图日期 Date 2026.07.27	展馆 Venue	图号 Drawing No.
	公司名称 Company Name 深圳燃气集团	审核 Approved by	比例 Scale A3 1:30	展位号 Hall No.	

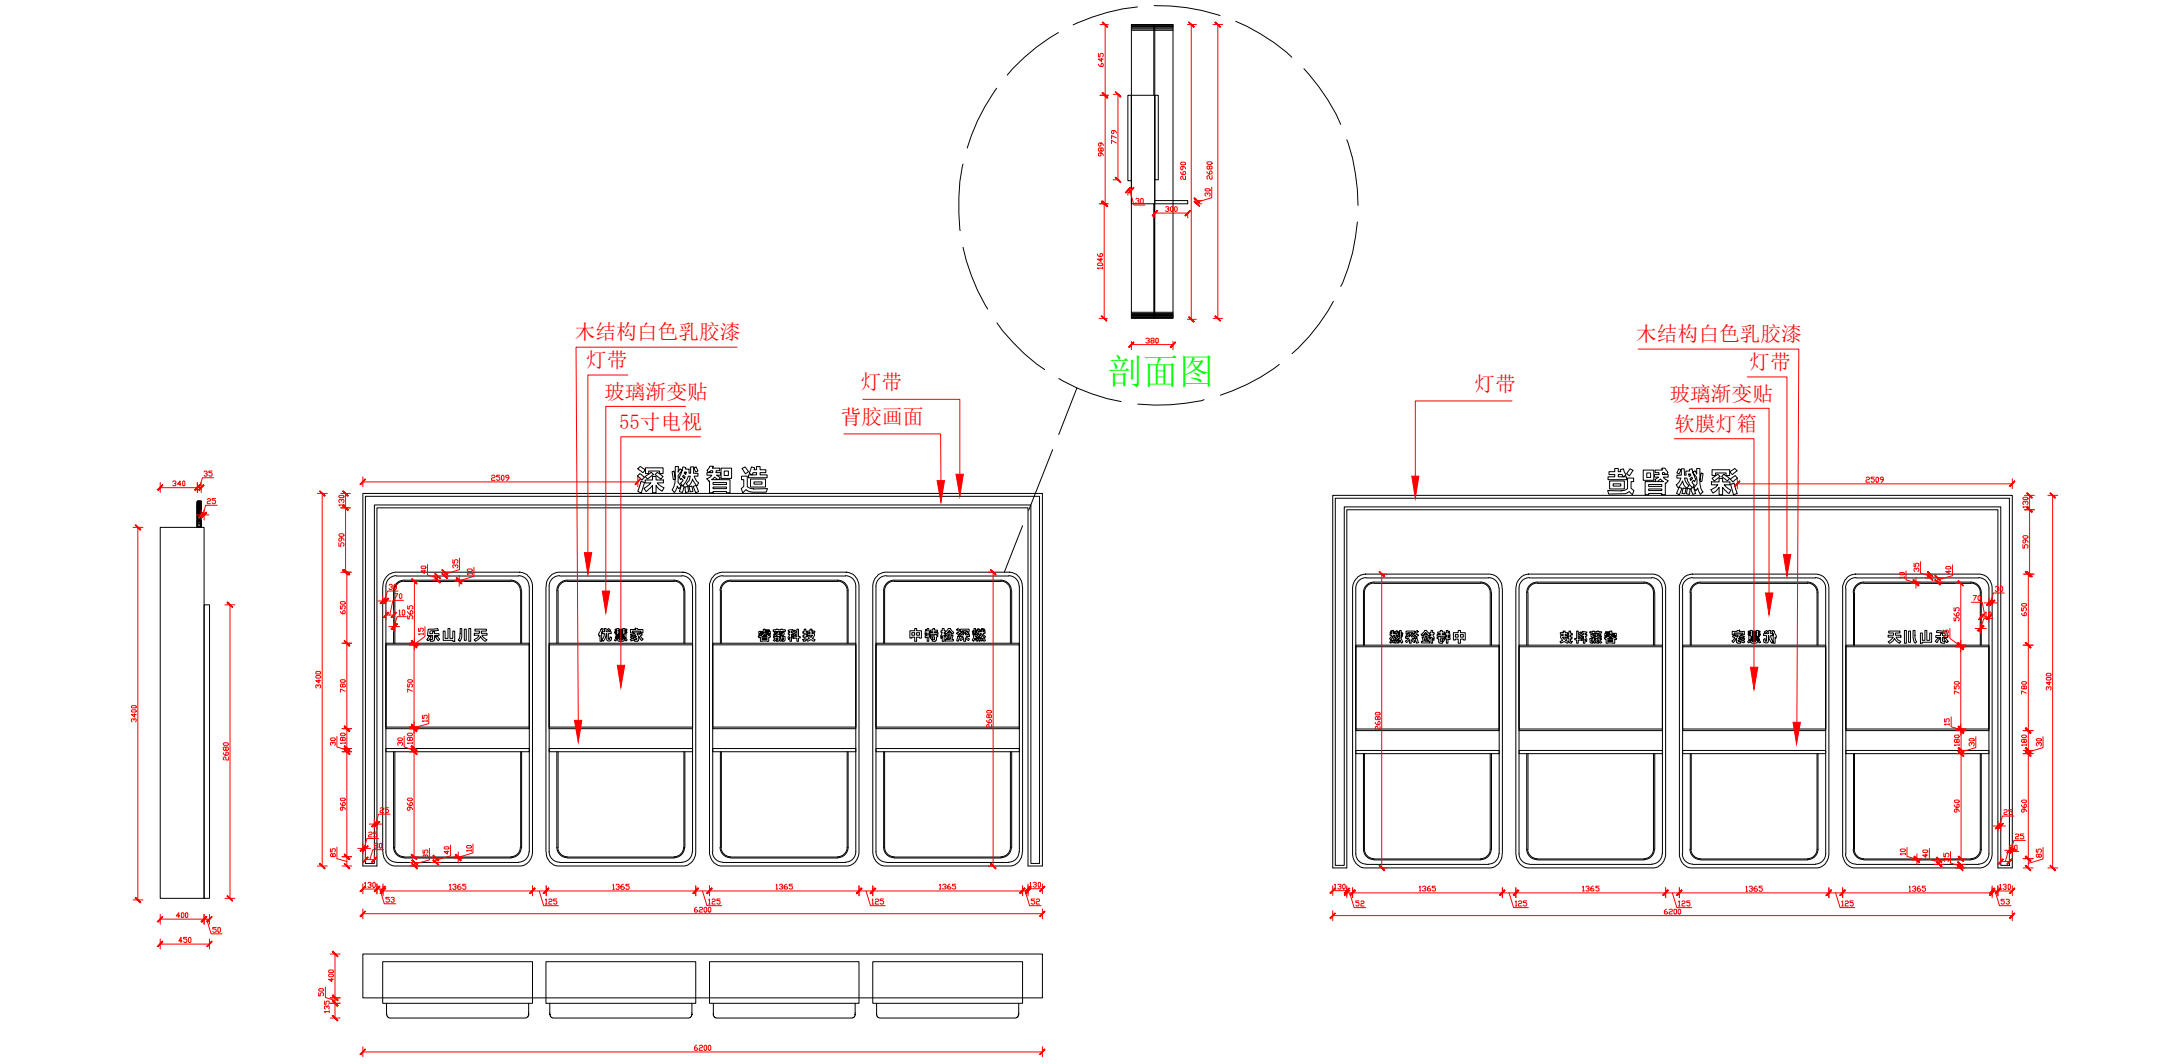


单位：mm

注释: 1. 全部设计图例及说明之版权属于本公司。 2. 所示尺寸均为施工单位现场量取为准。 3. 请根据现场实际情况进行尺寸调整。 4. 单位: mm(如无特殊注明单位均为毫米)。 NOTES 1. All the design plans and that the copyright of the Company without the consent of the Company, shall not be used, copied and reproduced. 2. Shown by the construction unit size, whichever is the scene review. 3. Drawings at the scene and if there are discrepancies, please notify the designer. 4. Unit: mm	展会名称 Exhibition Name	设计 Designer	制图日期 Date 2026.07.27	展馆 Venue	图号 Drawing No.
	公司名称 Company Name 深圳燃气集团	审核 Approved by	比例 Scale A3 1:30	展位号 Hall No.	





背墙C

该图为设计图纸，必须按图纸内所预留设计尺寸空间，如现场有变动或尺寸有调整，必需提前以文字形式通知设计师修改。

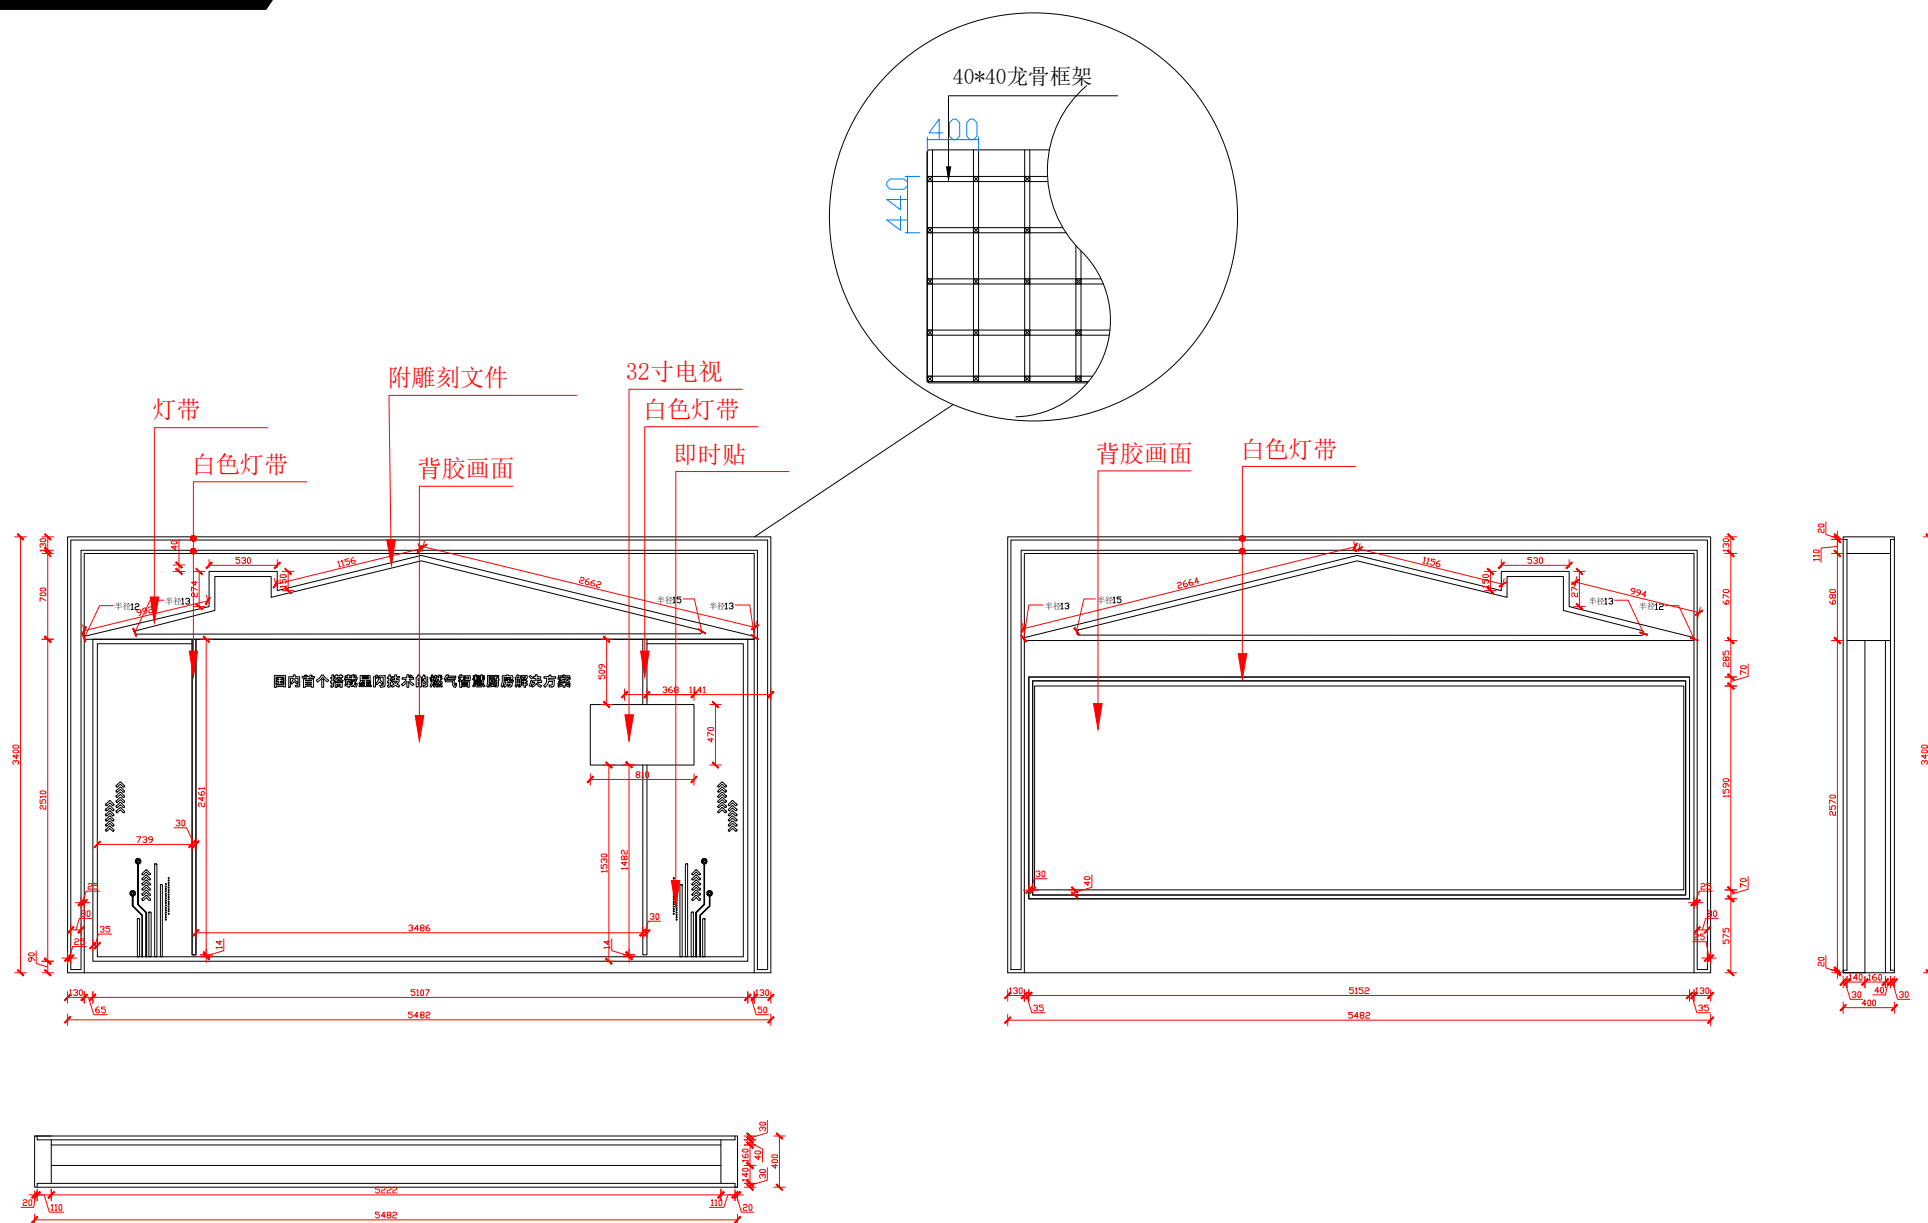

单位: mm

重庆融悦文化创意有限公司	注：1.全部设计图则及说明之版权属于本公司。 2.所示尺寸须由施工单位现场复核为准。 3.图则若与现场有不符之处请即通知设计师。 4.单位：mm(如无特别注明单位尺寸为毫米)。 NOTES 1. All the design plans and that the copyright of the Company without the consent of the Company, shall not be used, copied and reproduced. 2. Shown by the construction unit size, whichever is the scene review. 3. Drawings at the scene and if there are discrepancies, please notify the designer. 4. Unit: mm	展会名称 Exhibition Name	设计 Designer	制图日期 Date	2026.07.27	展馆 Venue	图号 Drawing No.
		公司名称 Company Name	审核 Approved by	比例 Scale	A3 1:30 	展位号 Hall No.	

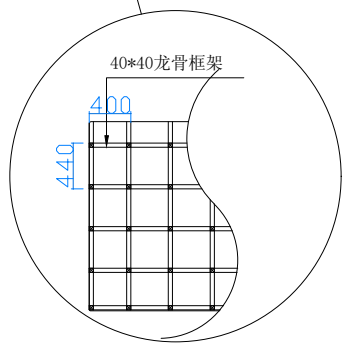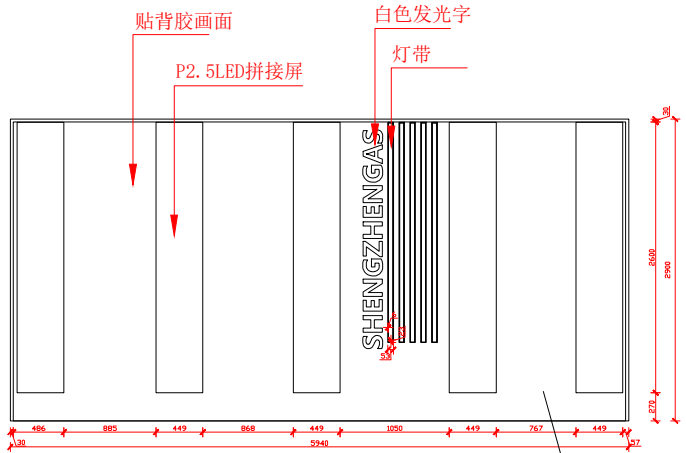
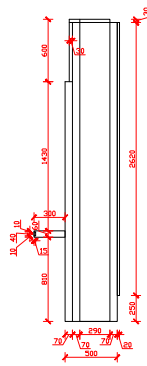
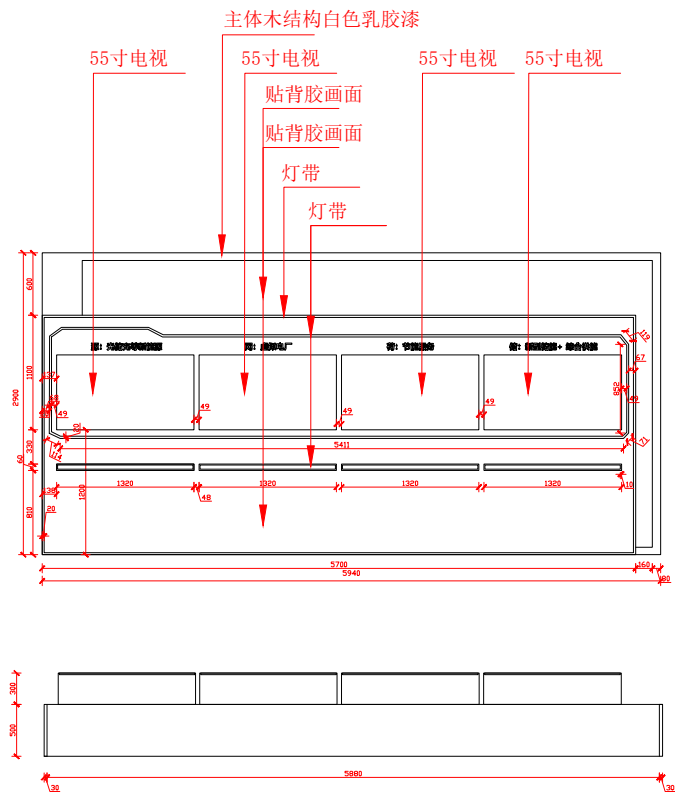


单位：mm



注释: 1.全部设计图则及说明之版权属于本公司 2.所示尺寸以现场施工单位现场量测为准 3.图则若有与现场不符之处,以现场实际设计为准 4.单位: mm(如无特殊注明,单位均为毫米) NOTES 1. All the design plans and that the copyright of the Company without the consent of the Company, shall not be used, copied and reproduced. 2. Shown by the construction unit size, whichever is the scene review. 3. Drawings at the scene and if there are discrepancies, please notify the designer. 4. Unit: mm	展会名称	设计	制图日期	展馆	图号
	Exhibition Name	Designer	Date	Venue	Drawing No.
公司名称	审核	比例	展位号		
Company Name	Approved by	Scale	Hall No.		

展示柜D-2


 

该图为设计图纸，必须按图纸内所预留设计尺寸空间，如现场有变动或尺寸有调整，必需提前以文字形式通知设计师修改。

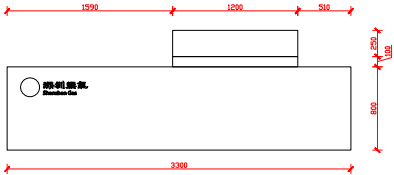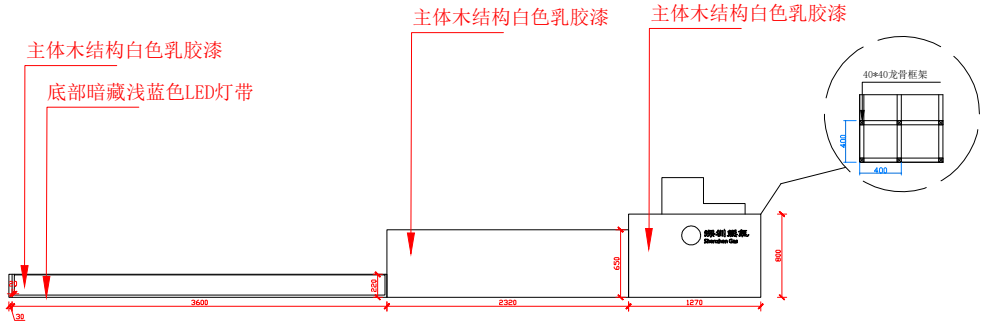

A

  


B

  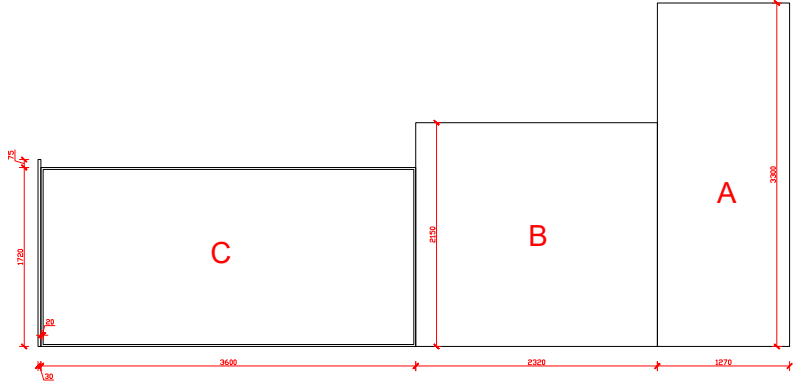

C

单位：mm


注释: 1.全部设计图则及说明之版权属于本公司 2.所示尺寸皆由施工单位现场量测为准 3.图则若有与现场不符之处,以现场实际设计为准 4.单位: mm(如无特殊注明单位尺寸为毫米) NOTES 1. All the design plans and that the copyright of the Company without the consent of the Company,shall not be used, copied and reproduced. 2. Shown by the construction unit size, whichever is the scene review. 3. Drawings at the scene and if there are discrepancies, please notify the designer. 4. Unit: mm	展会名称	设计	制图日期	展馆	图号
	Exhibition Name	Designer	Date	Venve	
	公司名称	审核	比例	展位号	
Company Name	深圳燃气集团	Approved by	Scale	A3 1:30	Hall No.

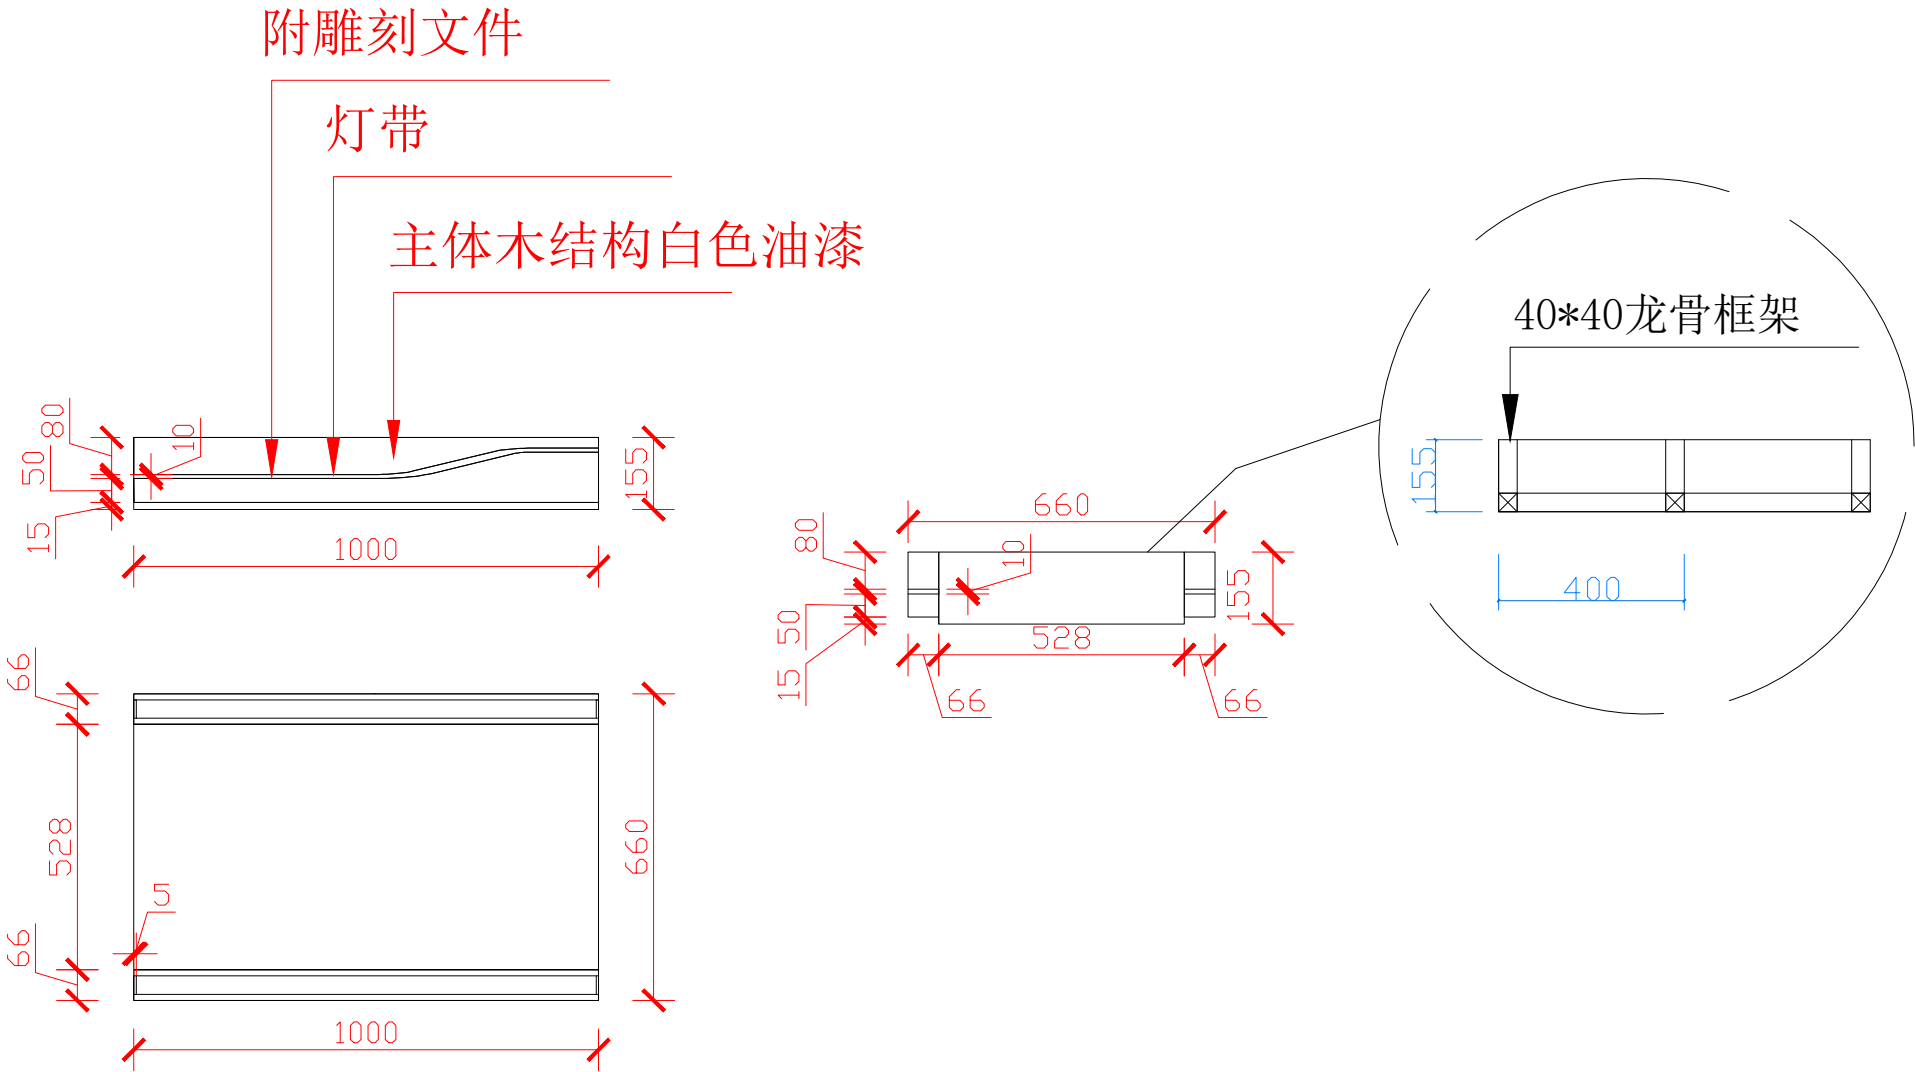

单位：mm

数量：1

注释: 1. 全部设计图例及说明之版权属于本公司。 2. 所示尺寸须由施工单位现场量测为准。 3. 图例若有与现场不符之处, 请通知设计师。 4. 单位: mm (如无特殊注明单位均为毫米)。 NOTES: 1. All the design plans and that the copyright of the Company without the consent of the Company shall not be used, copied and reproduced. 2. Shown by the construction unit size, whichever is the scene review. 3. Drawings at the scene and if there are discrepancies, please notify the designer. 4. Unit: mm	展会名称 Exhibition Name	设计 Designer	制图日期 Date 2026.07.27	展馆 Venue	图号 Drawing No.
	公司名称 Company Name 深圳燃气集团	审核 Approved by	比例 Scale A3 1:30	展位号 Hall No.	

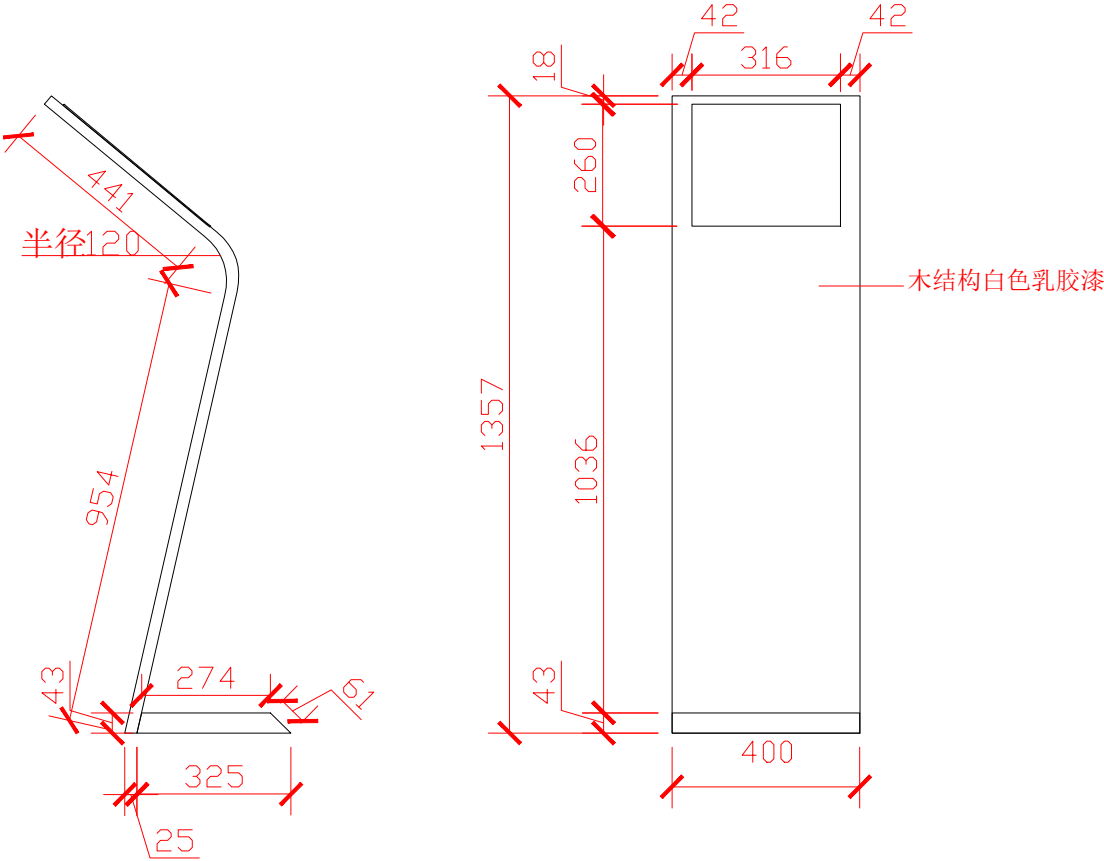


单位：mm

数量：2

注释: 1.全部设计图则及说明之版权属于本公司 2.所示尺寸须由施工单位现场量核为准 3.图纸若有与现场不符之处,须由设计单位 4.单位: mm(如无特殊注明单位尺寸为毫米) NOTES 1. All the design plans and that the copyright of the Company without the consent of the Company, shall not be used, copied and reproduced. 2. Shown by the construction unit size, whichever is the scene review. 3. Drawings at the scene and if there are discrepancies, please notify the designer. 4. Unit: mm	展会名称	设计	制图日期	展馆	图号
	Exhibition Name	Designer	Date	Venue	
公司名称	深圳燃气集团	审核	比例	展位号	Hall No.
Company Name		Approved by	Scale		

背墙E

该图为设计图纸，必须按图纸内所预留设计尺寸空间，如现场有变动或尺寸有调整，必需提前以文字形式通知设计师修改。






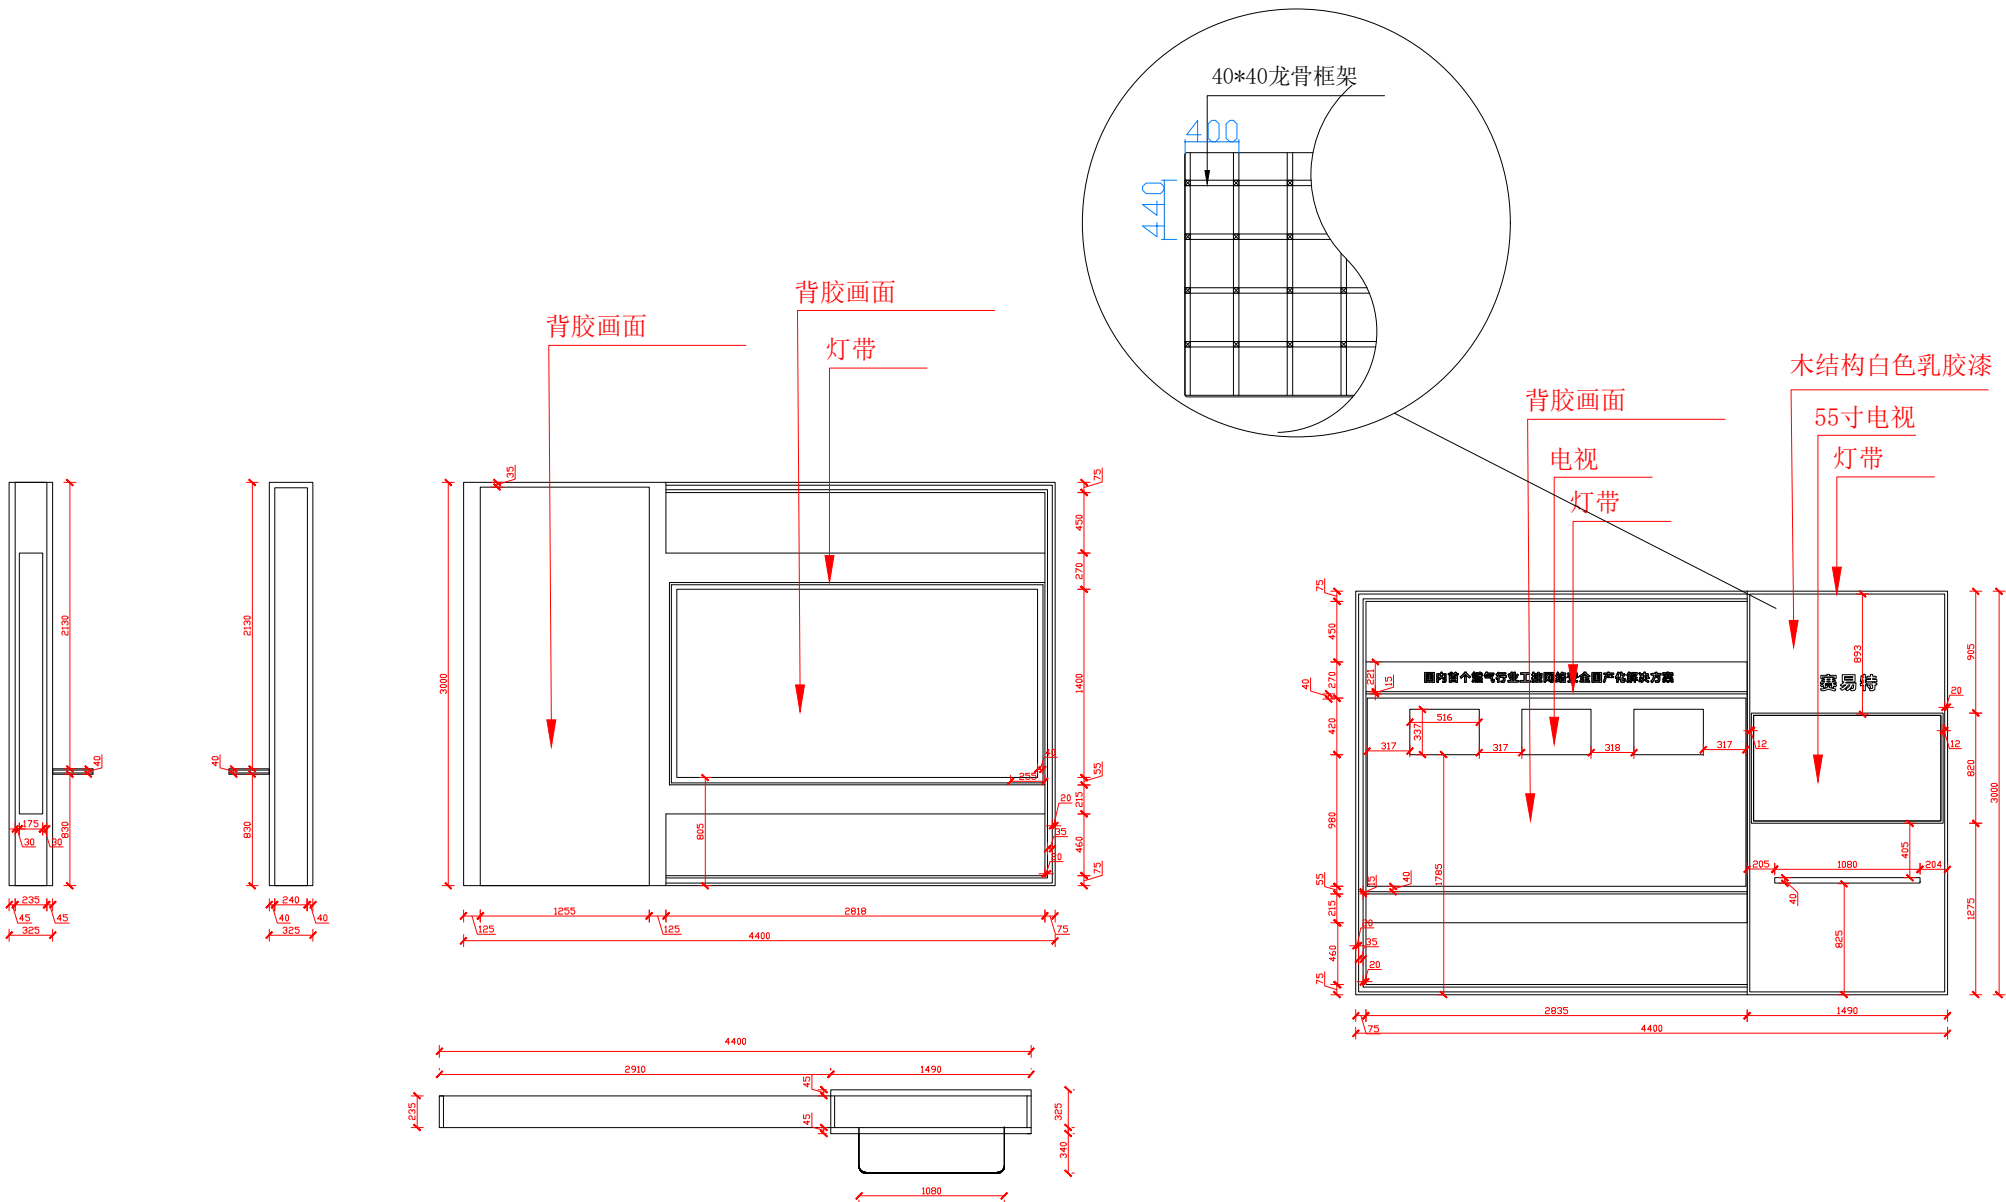


单位：mm

注释: 1.全部设计图则及说明之版权属于本公司 2.所示尺寸均为施工单位现场量取为准 3.图纸标注与现场不符之处以现场实际情况为准 4.单位: mm(如无特殊注明单位尺寸均为毫米) NOTES 1. All the design plans and that the copyright of the Company without the consent of the Company, shall not be used, copied and reproduced. 2. Shown by the construction unit size, whichever is the scene review. 3. Drawings at the scene and if there are discrepancies, please notify the designer. 4. Unit: mm	展会名称	设计	制图日期	展馆	图号
	Exhibition Name	Designer	Date	Venue	
	公司名称	审核	比例	展位号	
	Company Name	Approved by	Scale	Hall No.	Drawing No.

背墙F

该图为设计图纸，必须按图纸内所预留设计尺寸空间，如现场有变动或尺寸有调整，必需提前以文字形式通知设计师修改。

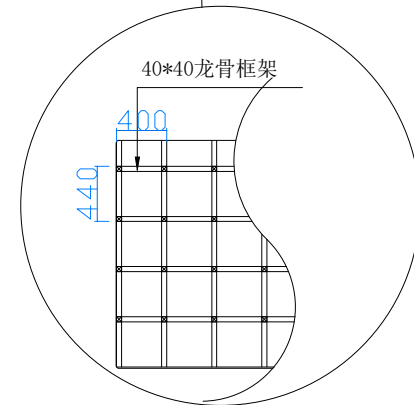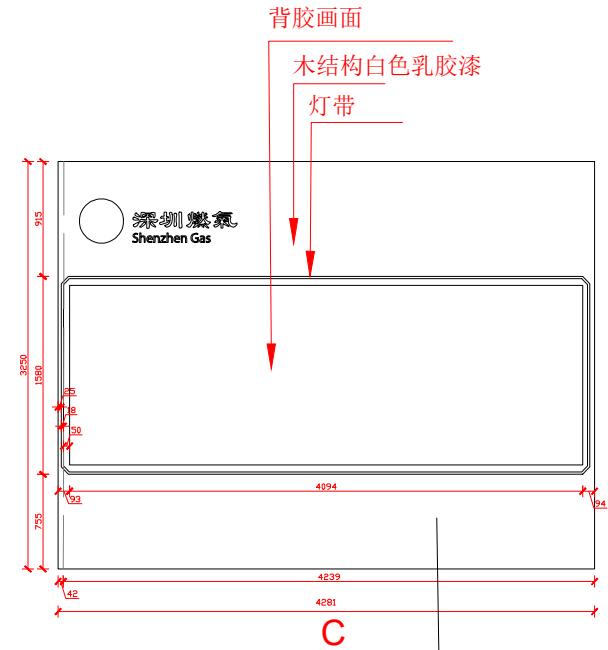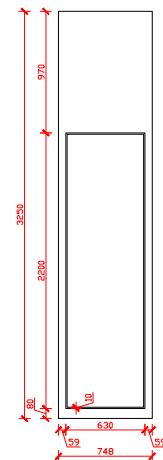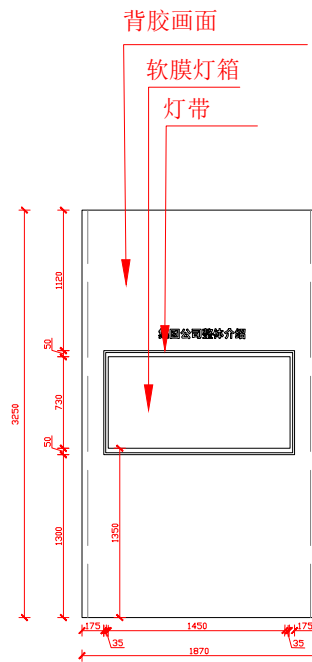
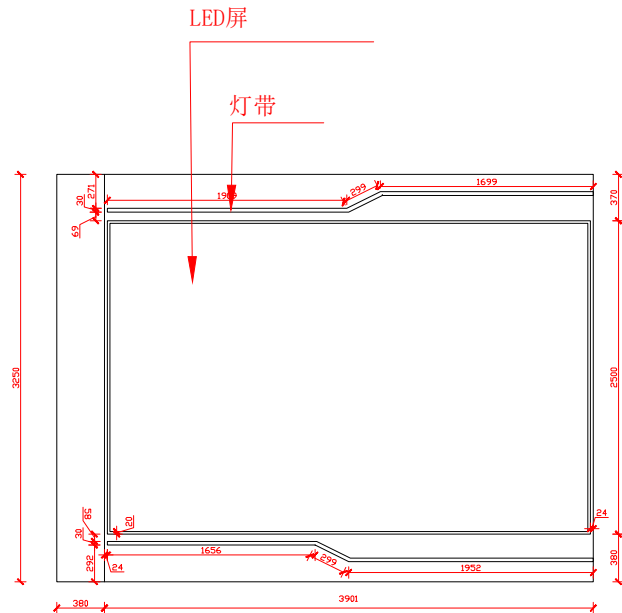
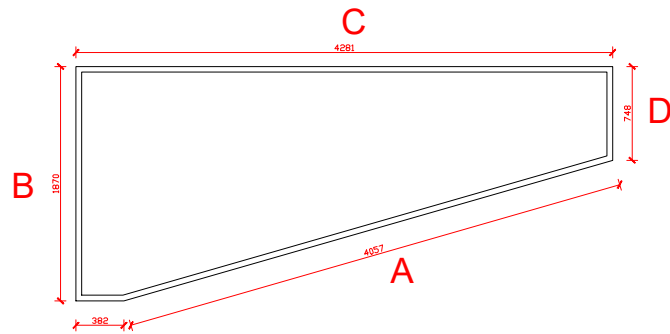


单位: mm

注釋: 1.全部設計圖則及說明之版權屬於本公司 2.所示尺寸與施工單位現場量測為準 3.圖則尺寸與現場不符之處請參照設計說明 4.單位: mm(除另有標註外,圖則尺寸均為毫米) NOTES 1. All the design plans and the copyright of the Company without the consent of the Company,shall not be used, copied and reproduced. 2. Shown by the construction unit size, whichever is the scene review. 3. Drawings at the scene and if there are discrepancies, please notify the designer. 4. Unit: mm	展会名称 Exhibition Name	设计 Designer	制图日期 Date 2026.07.27	展馆 Venve	图号 Drawing No.
	公司名称 Company Name 深圳燃气集团	审核 Approved by	比例 Scale A3 1:30 	展位号 Hall No.	

接待台

该图为设计图纸，必须按图纸内所预留设计尺寸空间，如现场有变动或尺寸有调整，必需提前以文字形式通知设计师修改。

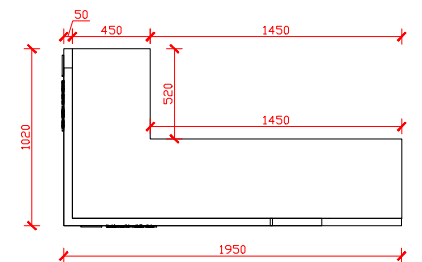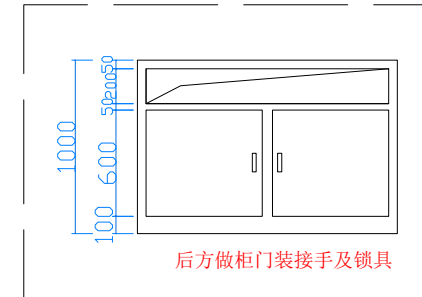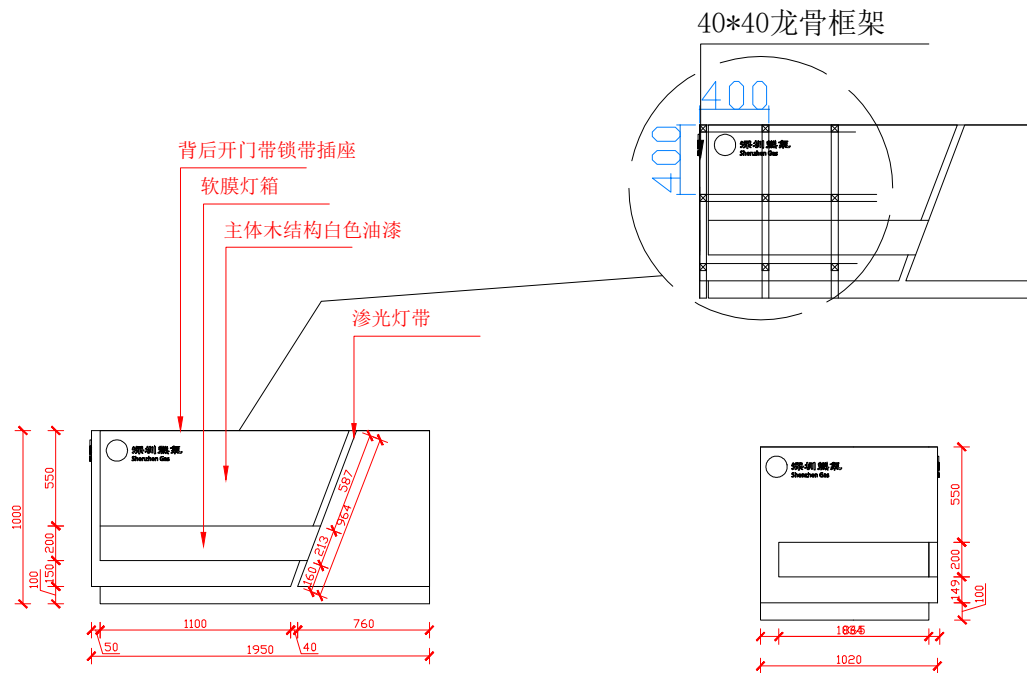


单位: mm

数量: 1

注釋: 1.全部設計圖則及說明之版權屬於本公司。 2.所示尺寸須由施工單位現場复核為準。 3.圖紙若有現場有不符之處請通知設計師。 4.單位: mm(除特別註明單位尺寸外均為毫米)。 NOTES 1. All the design plans and the copyright of the Company without the consent of the Company,shall not be used, copied and reproduced. 2. Shown by the construction unit size, whichever is the scene review. 3. Drawings at the scene and if there are discrepancies, please notify the designer. 4. Unit: mm	展会名称 Exhibition Name	设计 Designer	制图日期 Date 2026.07.27	展馆 Venve	图号 Drawing No.
	公司名称 Company Name 深圳燃气集团	审核 Approved by	比例 Scale A3 1:30	展位号 Hall No.	


该图为设计图纸，必须按图纸内所预留设计尺寸空间，如现场有变动或尺寸有调整，必需提前以文字形式通知设计师修改。

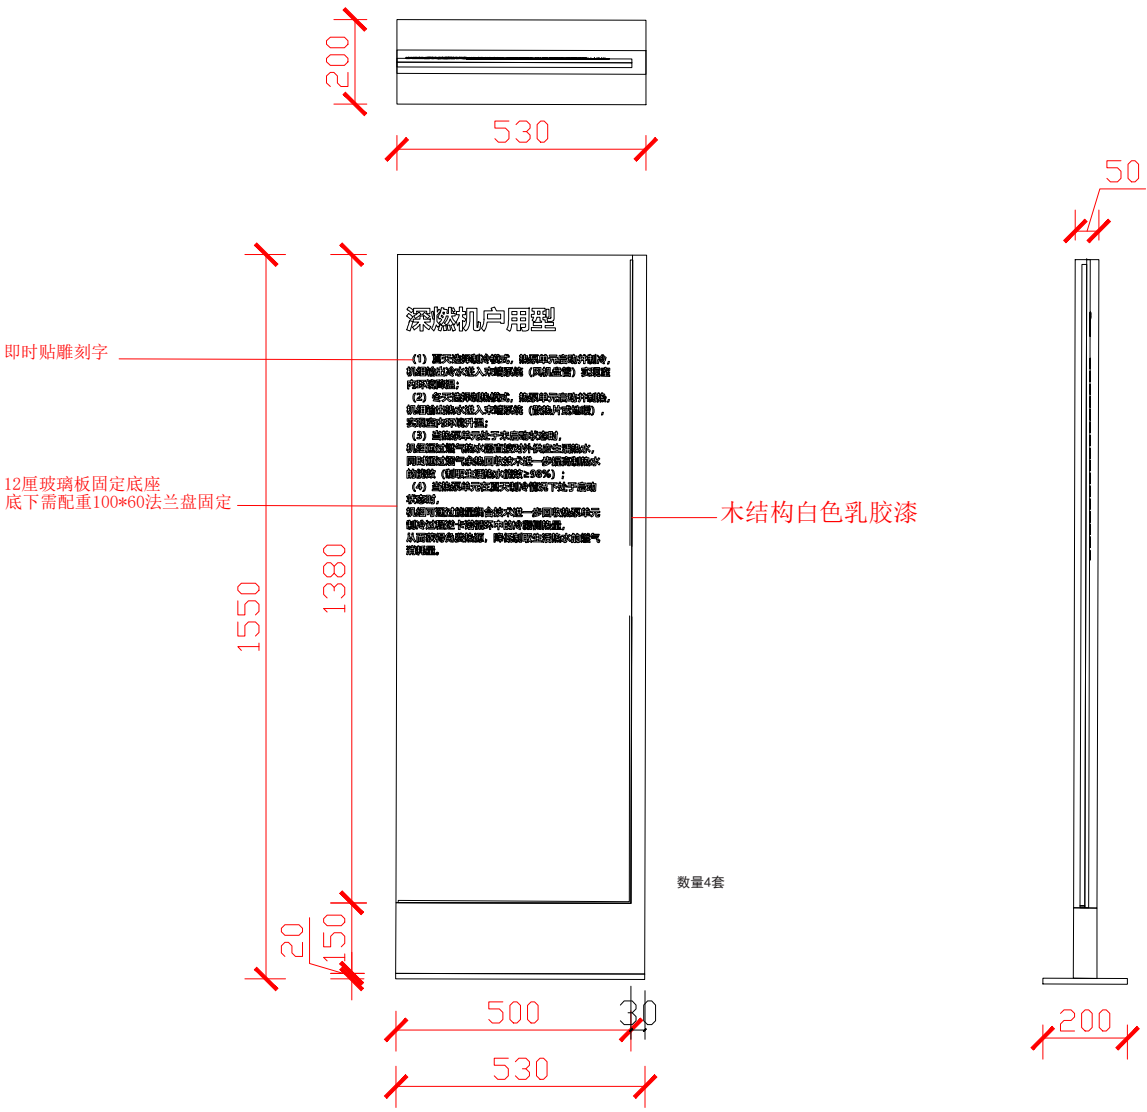


单位：mm

数量：4


注释: 1.全部设计图则及说明之版权属于本公司 2.所示尺寸均为施工单位现场量取为准 3.请按照现场所有尺寸之标注进行施工 4.单位: mm(如无特殊注明单位尺寸为毫米) NOTES 1. All the design plans and that the copyright of the Company without the consent of the Company, shall not be used, copied and reproduced. 2. Shown by the construction unit size, whichever is the scene review. 3. Drawings at the scene and if there are discrepancies, please notify the designer. 4. Unit: mm	展会名称	设计	制图日期	展馆	图号
	Exhibition Name	Designer	Date	Venue	Drawing No.
	公司名称	审核	比例	展位号	
	Company Name	Approved by	Scale	Hall No.	

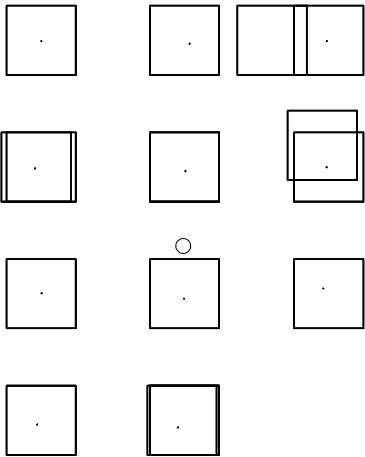

亚克力画面装置盒

 

数量：17

 




单位：mm

注释: 1.全部设计图则及说明之版权属于本公司 2.所示尺寸均为施工单位现场量测为准 3.图纸若有与现场不符之处,以现场实际情况为准 4.单位: mm(如无特殊注明单位尺寸为毫米) NOTES 1. All the design plans and that the copyright of the Company without the consent of the Company, shall not be used, copied and reproduced. 2. Shown by the construction unit size, whichever is the scene review. 3. Drawings at the scene and if there are discrepancies, please notify the designer. 4. Unit: mm	展会名称	设计	制图日期	展馆	图号
	Exhibition Name	Designer	Date	Venue	
公司名称	审核	比例	A3 1:30	展位号	Hall No.
Company Name	Approved by	Scale			

深圳燃气集团

地台结构图

该图为设计图纸，必须按图纸内所预留设计尺寸空间，如现场有变动或尺寸有调整，必需提前以文字形式通知设计师修改。

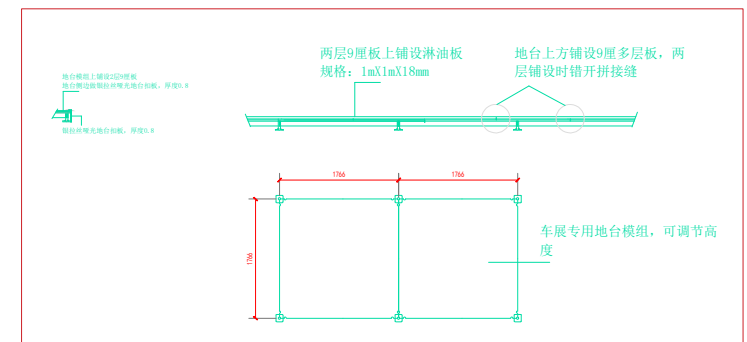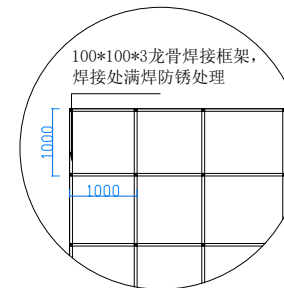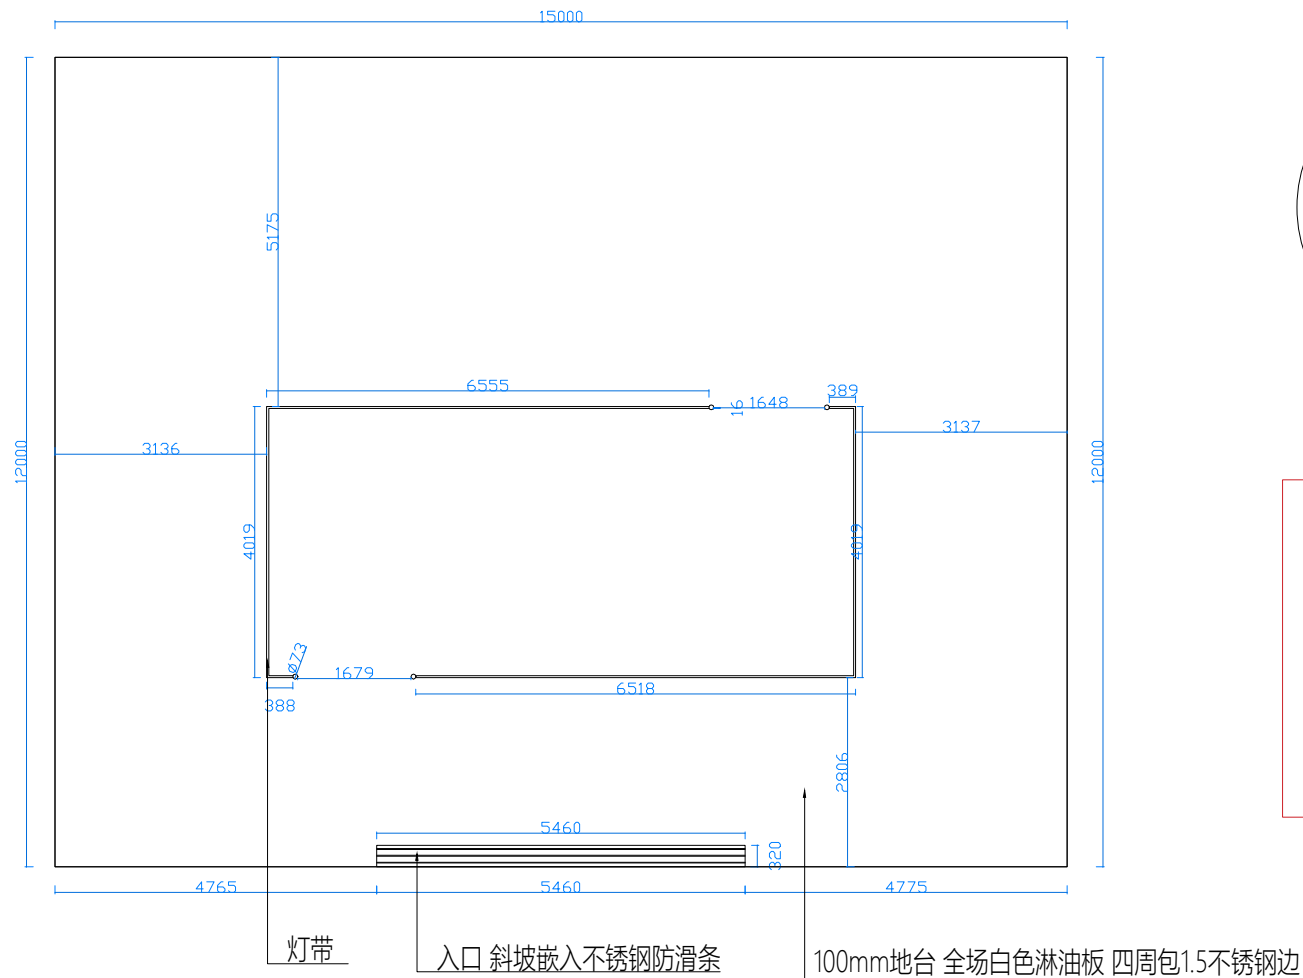

单位: mm

注釋: 1.全部設計圖則及說明之版權屬於本公司。 2.所示尺寸須由施工單位現場复核為準。 3.圖紙若有現場有不符之處請通知設計師。 4.單位: mm(除特別註明單位尺寸外均為mm)。 NOTES 1. All the design plans and the copyright of the Company without the consent of the Company,shall not be used, copied and reproduced. 2. Shown by the construction unit size, whichever is the scene review. 3. Drawings at the scene and if there are discrepancies, please notify the designer. 4. Unit: mm	展会名称 Exhibition Name	设计 Designer	制图日期 Date 2026.07.27	展馆 Venve	图号 Drawing No.
	公司名称 Company Name 深圳燃气集团	审核 Approved by	比例 Scale A3 1:30	展位号 Hall No.	